



HELI CAFE

HELI CAFE


PROFILE



SUMMARY

In 2021, an Emirati dream came true by importing MBB-BO-105 helicopter to the UAE. The helicopter has undergone internal and external renovation by THEFOODTRUCK.CO (TVT Trailer Manufacturing Company) which specializes in custom building businesses on wheels. It was provided with the latest commercial equipment in order to prepare specialty hot and cold coffee, cold beverages, petite deserts and ice-cream inside the cabin following Dubai food health and safety regulations.

It will be the first of its kind in the UAE and the Middle Eastern region for a mobile helicopter serving specialty coffee. The idea was built by moving towards an innovative work away from the well-known scale of food trucks in the region which will be attracting individuals of different ages and tourists to enjoy a new experience.

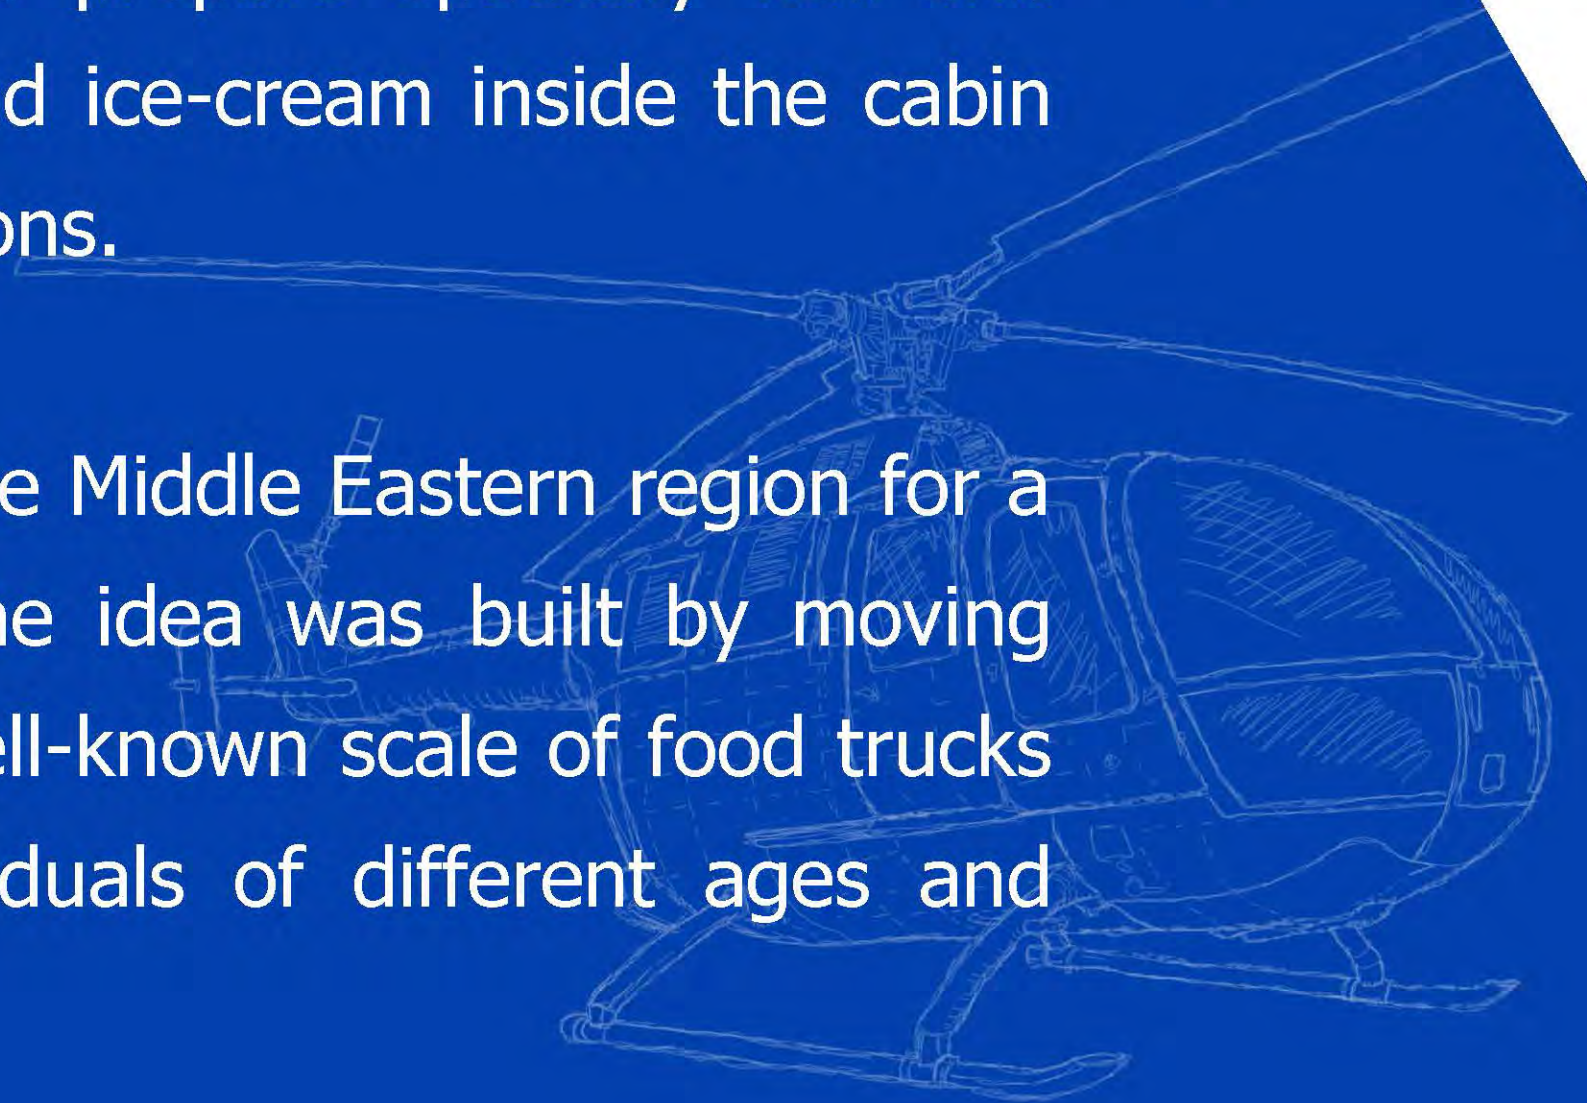

ABOUT HELICAFE

Mission

To inspire and nurture the human spirit by providing specialized and distinctive coffee with a new experience

Values

Creativity - Passion - Customer's respect - Premium quality

Vision

To be the one of kind and the first destination to visit for enjoying specialty coffee in the UAE. Innovation and orientation towards creativity and creating media opportunities in the UAE and the Middle East, offering high quality products and new experienced services.

SPECIFICATIONS & DESIGN FEATURES

COLOR OF THE HELICOPTER

70% Blue Color

30% Orange color



Technical Specifications: -

- 1. All European insulation works, inside and out, to resist heat and fire**
- 2. 18-Socket Black British standard 230v ip54**
- 3. 3 Cameras**
- 4. Indicative lights on the trailer**
- 5. 3 External speakers**
- 6. Polished aluminium checker plate with diamond shape projections**
- 7. DJ MIXER**
- 8. LED interior lights**
- 9. European washbasin**
- 10. Floors with polyurea - polyurethane protective coatings to prevent slips and leaks**
- 11. aluminium cladding 2mm**
- 12. custom helicopter trailer 10 x 2.6 bearing more than 3500 Kg**
- 13. 2 tanks 120-liter aluminium under the trailer**
- 14. Stainless steel upper shelves for storage**
- 15. Jabsco Par Max 3 Pump 31395-4012**
- 16. Fire extinguisher + fire blanket + first aid**
- 17. 3500-Kg Trailer Jack with Rubber Wheel**
- 18. 12V / N Type Extension Conversion Lead with Curly Cable - 7 Pin Plugs Trailers**
- 19. Black Trailer hook lock USA**
- 20. 4 tires 2021**



- 21. 4X4-Offroad Ball Hitch Mount**
- 22. Aluminium Tool Storage Box**
- 23. Wesco 3500 Kg Electric Trailer Jack Drop Leg Black with LED Light**
- 24. 6 pieces Scissor Jack Heavy-duty 3-Tonne Under the trailer**
- 25. 2 ladders**
- 26. Steel Electrical Distribution Box, Waterproof Power Distribution Board Panel**
- 27. split air conditioner 1.5-ton 2 year's warranty**
- 28. water drainage system**
- 29. Forming and carving the basic coffee beans shape using fiberglass 3 sizes**
- 30. PPF Ultra Protection (nano-care) was done with Self-Healing 5 year guarantee protects paint from scratches**




Equipment: -

- 1. Timemore 02 Dripper Black/Glass**
- 2. Timemore Coffee Server 600ml Glass**
- 3. Hario V60 Filter**
- 4. Timemore Basic+ Coffee Scale Black**
- 5. Timemore Electric Smart Kettle 600ml**
- 6. Food Display Fridge 160Ltr Black dim- (L756xD524xH735mm)**
- 7. Bar cooler capacity: 126Ltr dim- (L600 x D500 x H870 mm)**
- 8. Ice maker capacity: 47 kg / 24 hours dim (L 485 x D 575 x H 810 mm)**
- 9. Victoria Arduino Machine Eagle One V 2GR - Black**
- 10. Eureka ATOM Specialty Grinder -75E chrome**
- 11. 2 - Xylem - Flojet Bottled Water System Single wand**
- 12. Rhino Corner Tamper Mat**
- 13. Rhinowares - Thumpa Floor Standing Knock Tube**
- 14. BG-Coffee Distributor -Black 58mm**
- 15. BG-Tamper Black 58.4mm**
- 16. VST Baskets 18gm Ridgeless**
- 17. Rhinoware -2.4Oz Shot Pitcher with Handle**
- 18. Acaia Lunar Coffee Scale - Black**
- 19. Acaia Black Pearl Smart Scale - Model S**
- 20. Barista Space-Milk Pitcher Sandy Black 350ml**



- 21. Barista Space-Milk Pitcher Sandy Black 450ml**
- 22. Barista Space-Milk Pitcher Sandy Black 600ml**
- 23. Joe Glo - Pallo Group head Brush - Black - CTBLK**
- 24. Joe Glo - Pallo Grindminder Combination Brush - GM**
- 25. Cafetto - EVO(500gmsX 12 Jars Per Carton)**
- 26. Cafetto - Grinder Clean (450gx12p/car)**
- 27. chrome- Center Spray Rinser Tray 15"x7"x7/8" inches.**
- 28. Generaltec Low Noise Heavy Duty Mixture (2-liter - 1500w)**



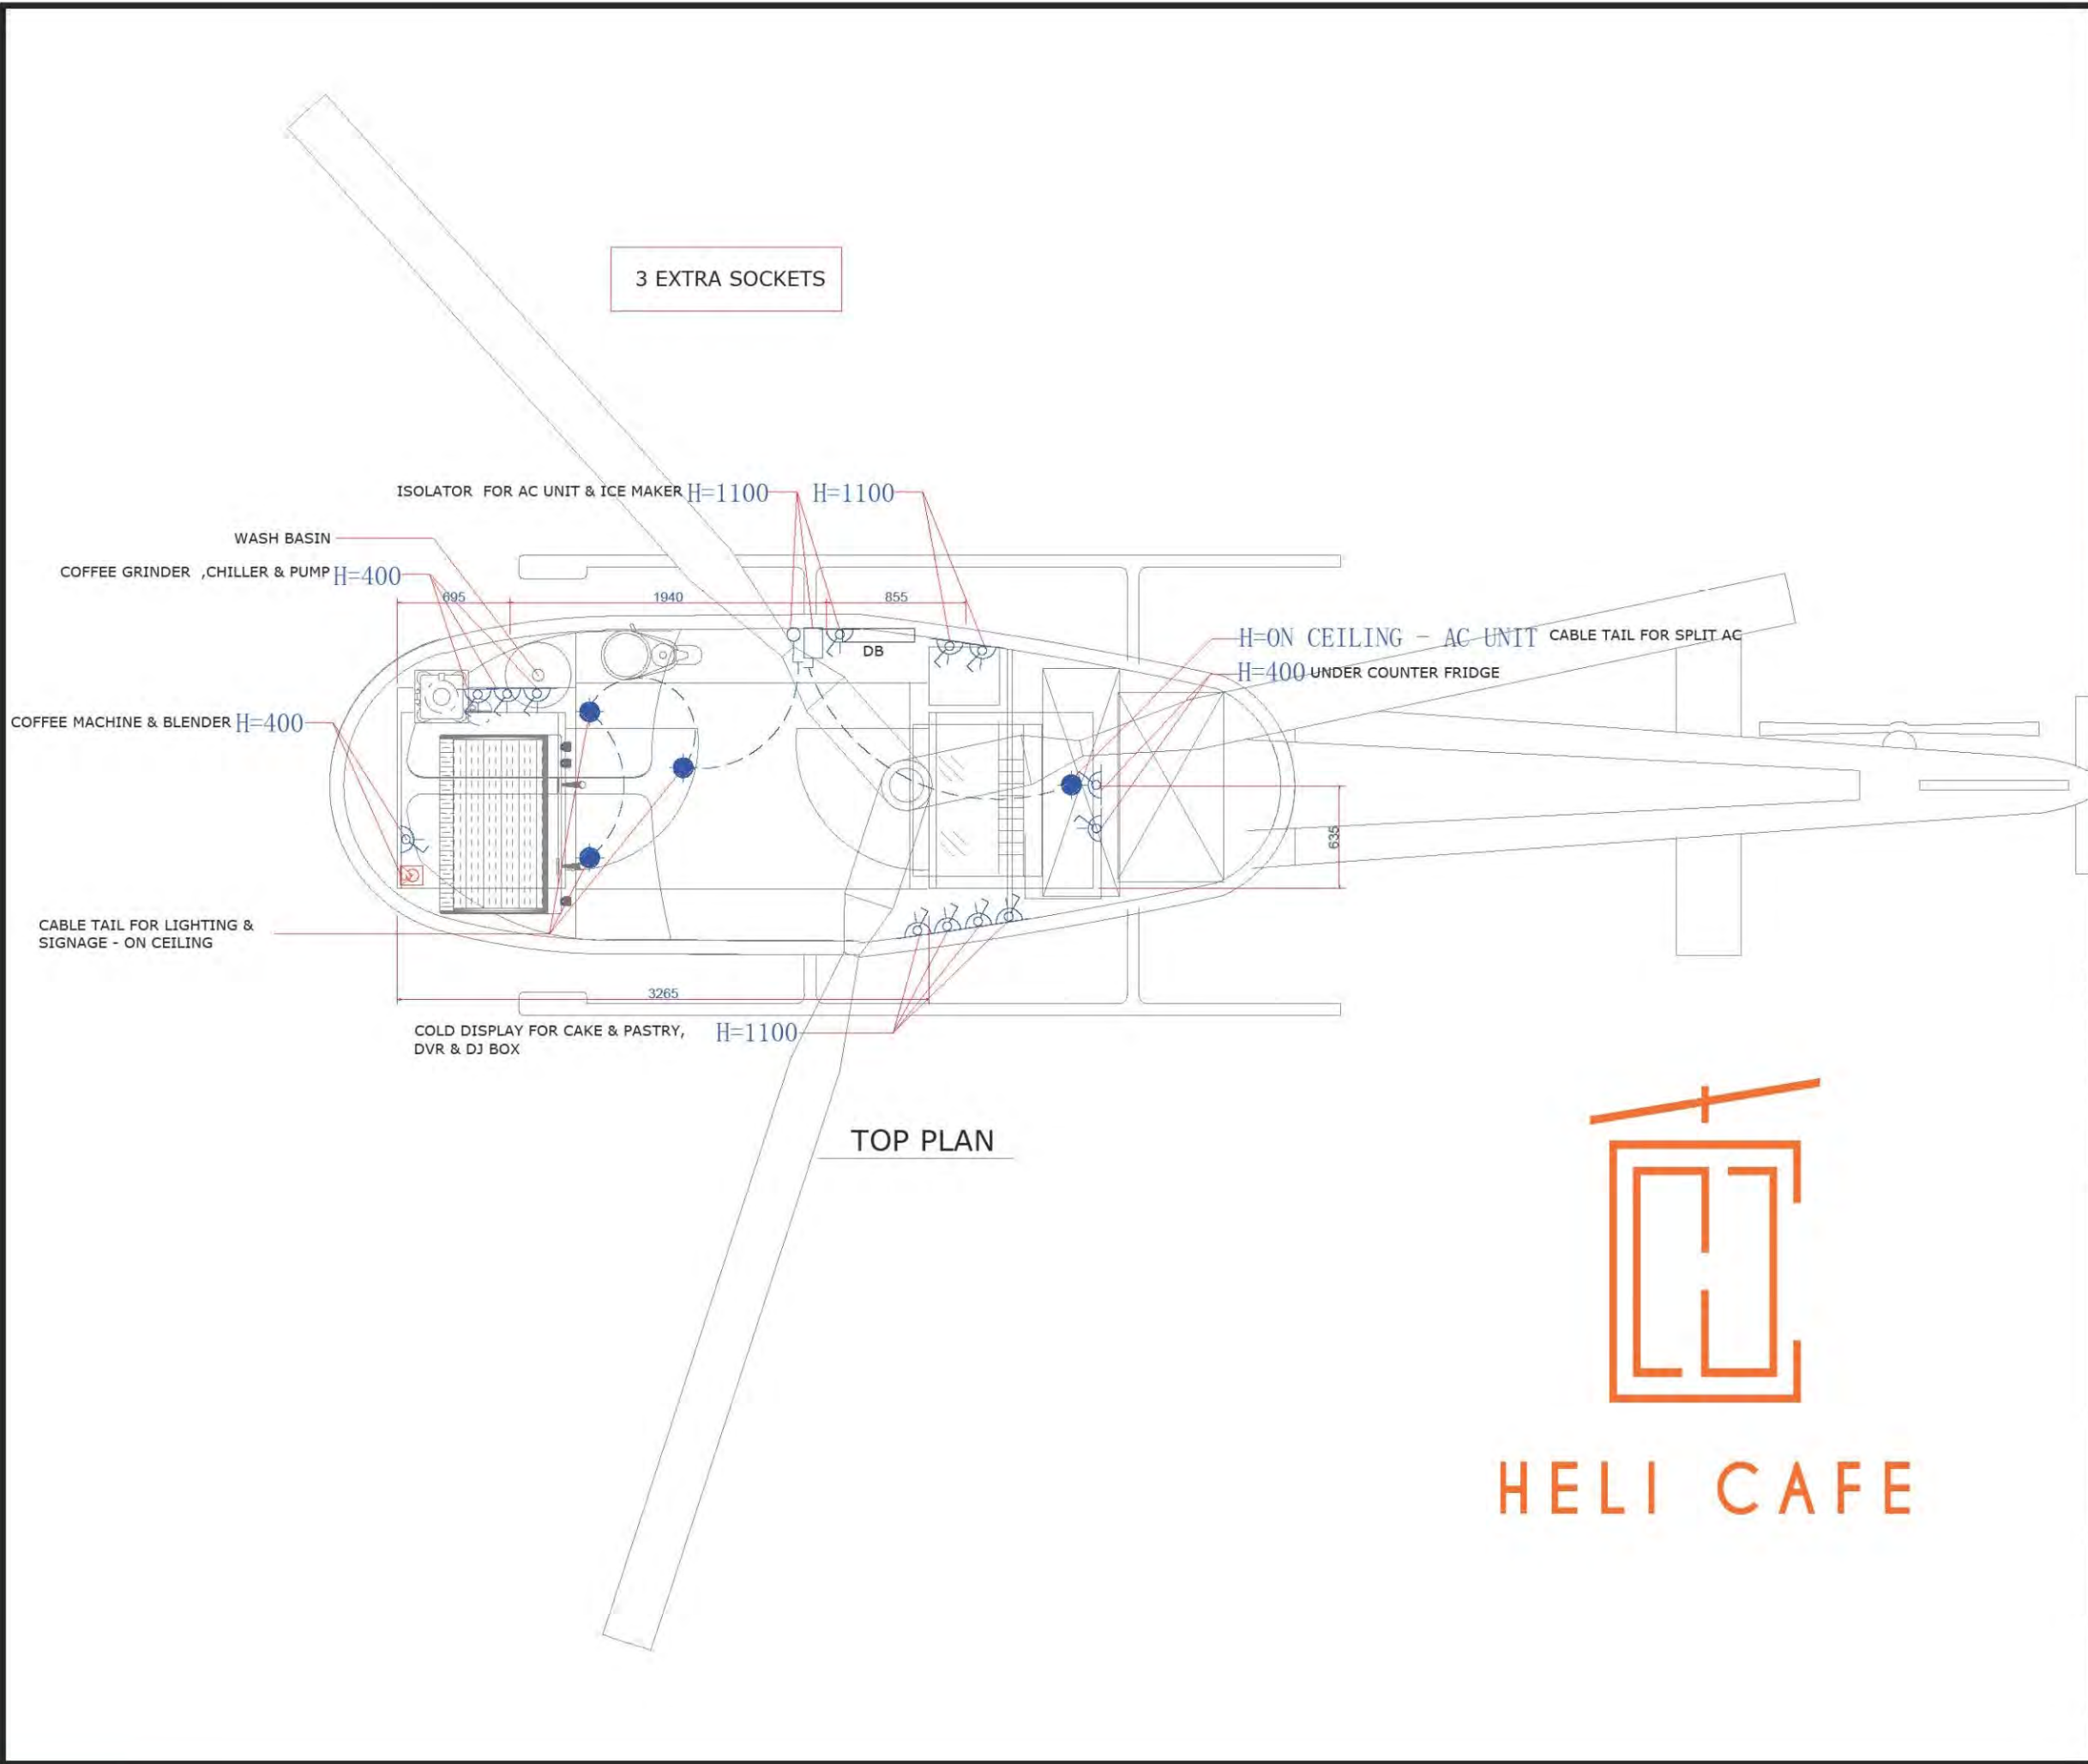

NOTES:

1. THE COPYRIGHT OF THIS DRAWING IS VESTED IN "THE FOODSTERS & MANUFACTURING THE FOODTRUCK.CO" NOT BE REPRODUCED IN WHOLE OR PART OR USED FOR THE MANUFACTURE OF ANY ARTICLE WITHOUT THE EXPRESS PERMISSION OF THE COPYRIGHT HOLDERS.
2. WORK TO FIGURED DIMENSIONS ONLY.
3. THIS DRAWING IS TO BE READ IN CONJUNCTION WITH ALL RELEVANT SERVICE ENGINEER'S AND PARTIES DRAWINGS AND SPECIFICATIONS.

NOTES

ALL ELECTRICAL OUTLET SHOULD INCLUDE ELECTRICAL WIRES, AND EXTENDED BY MINIMUM 1500mm LONG. ALL THREE PHASE SHOULD BE WITH GROUND AND NEUTRAL WIRES.

ELECTRICAL LEGEND

	13 AMP Switched Socket
	15 AMP Switched Socket
	Isolator - 3PH+N
	Isolator - 1PH
	20 AMP DP Switch WITH LIGHT 240V/150V
	32 AMP DP Switch WITH LIGHT
	WATER PROOF ELECTRICAL OUTLET JUNCTION BOX
	WALL MOUNTED ELECTRICAL OUTLET
	32 AMP 240V/150V PLUG MK MODEL K903BDU WITH SURFACE MODEL K13633 OR IDENTICAL
	32 AMP 415/240V + N PLUG MK MODEL MK9045 WITH SURFACE MODEL K13641 RED OR IDENTICAL
	HEIGHT FORM FINISHED FLOOR LEVEL
	Cable tail
	Ceiling Mounted Socket
	Control Switch
	HOOD LIGHT

REVISIONS

REV	DATE	DESCRIPTION	DRWN	CHKD	REVQ
	04.04.21	REV.1	AA		
	23.02.21		AA		
00	07.01.21	INITIAL DRAWING	AA		-

SCALE : _____ METERS

DESIGN & BUILD :

HELICOPTER - DESERT ROCK

PROJECT LOCATION :

UAE

DRAWING TITLE :

ELECTRICAL PLAN



PROJECT NUMBER :

DRAWING NUMBER :

SHEET SIZE

REV. NO.

A3

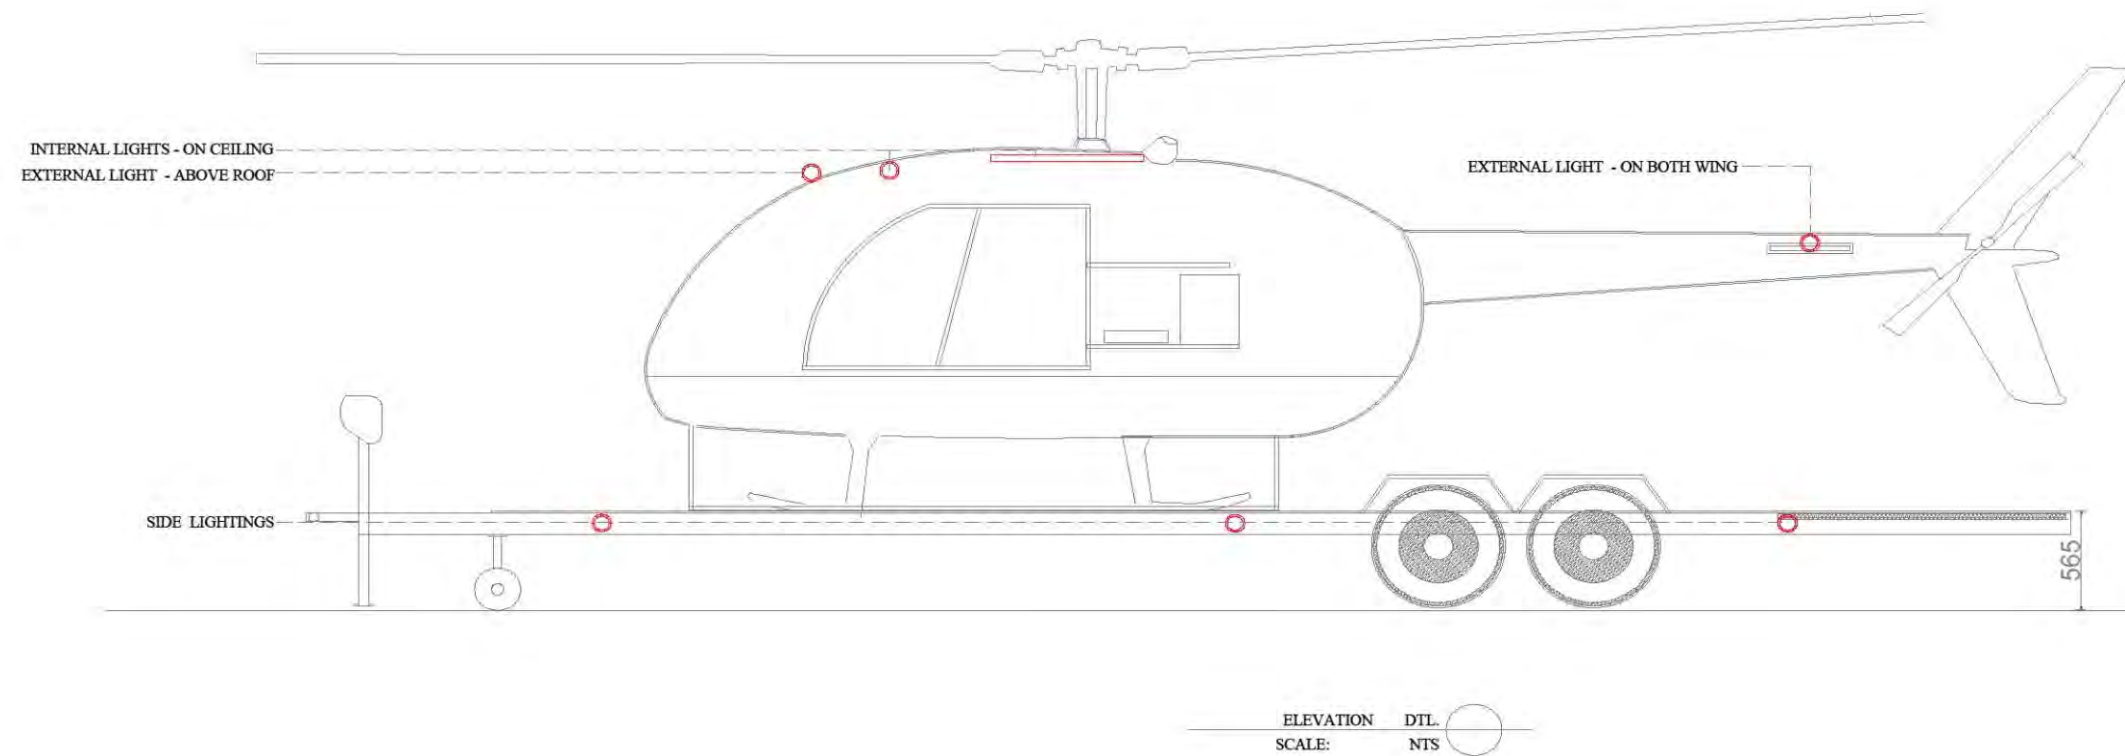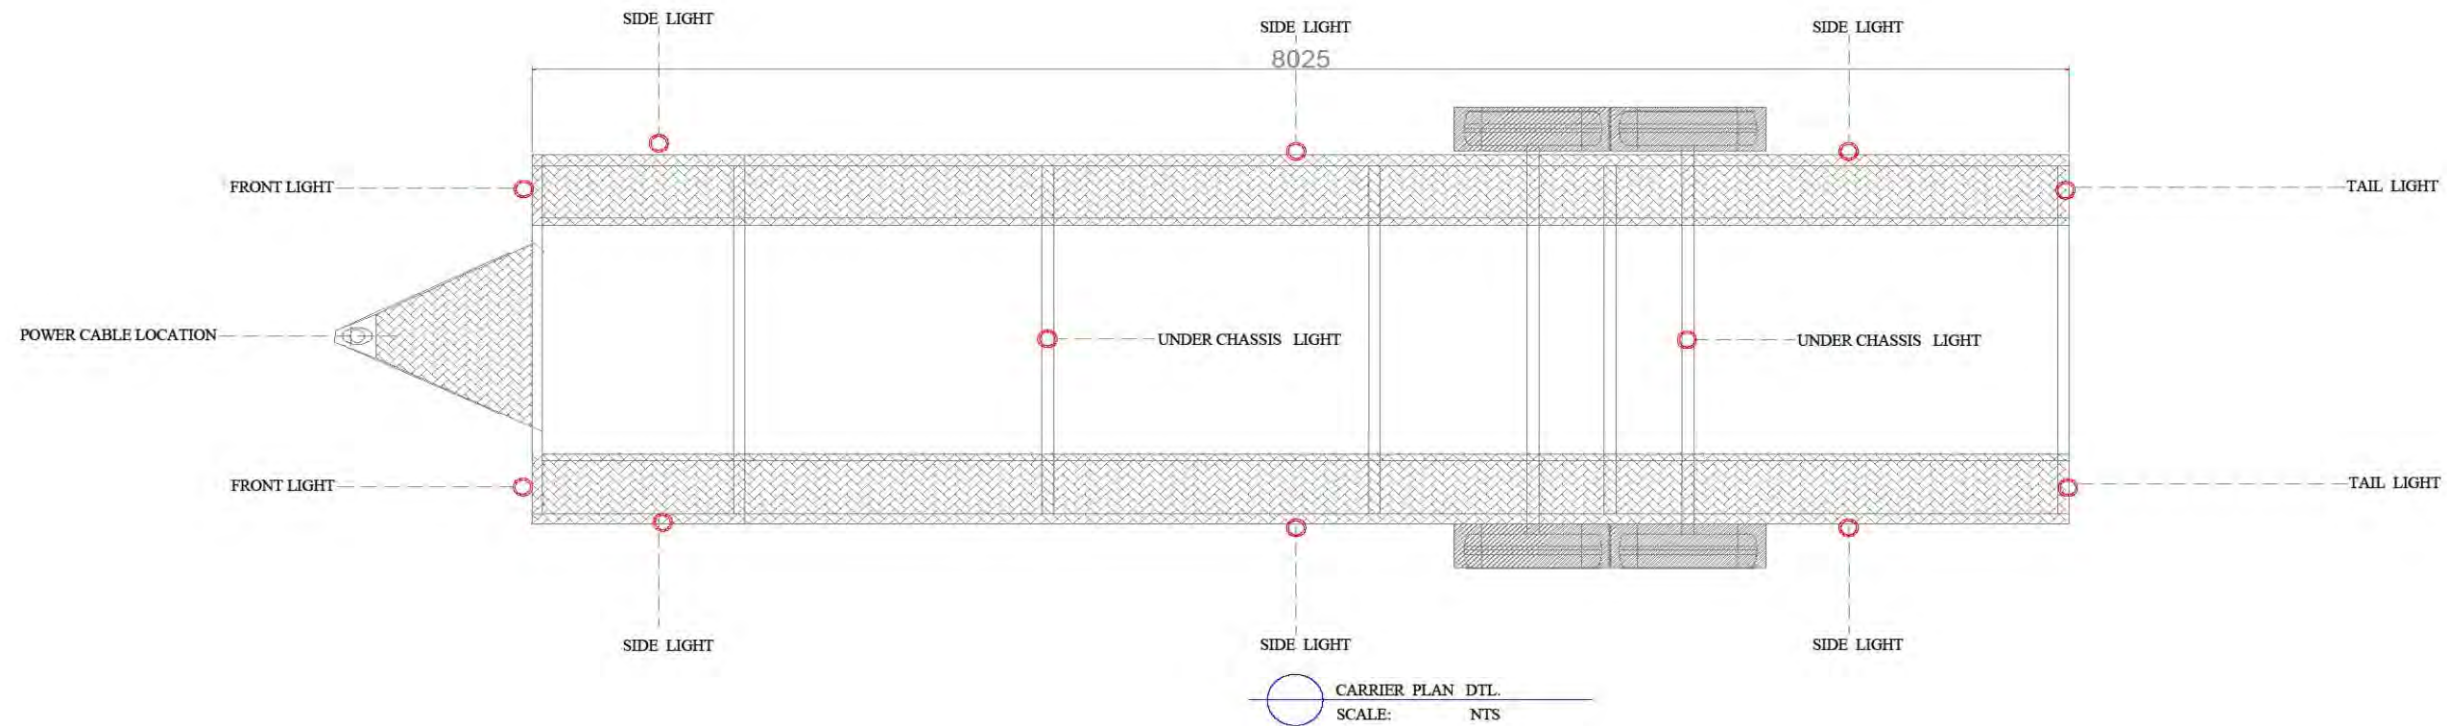

- NOTES:
1. THE COPYRIGHT OF THIS DRAWING IS VESTED IN "TVT TRAILERS MANUFACTURING LLC & THEFOODTRUCK.CO ". NOT BE REPRODUCED IN WHOLE OR PART OR USED FOR THE MANUFACTURE OF ANY ARTICLE WITHOUT THE EXPRESS PERMISSION OF THE COPYRIGHT HOLDERS.
 2. WORK TO FIGURED DIMENSIONS ONLY.
 3. THIS DRAWING IS TO BE READ IN CONJUNCTION WITH ALL RELEVANT SERVICE ENGINEER'S AND PARTIES DRAWINGS AND SPECIFICATIONS.



REVISIONS

REV	DATE	DESCRIPTION	DRWN	CHKD	REVD
00	07-04-2021	INITIAL DRAWING	AA	-	-

SCALE : _____ METERS

DESIGN & BUILD :

PC

CLIENT

HELICOPTER - DESERT ROCK

PROJECT LOCATION :

DUBAI - UAE

DRAWING TITLE :

DWG. TYPE


LIGHTING LAYOUT

PROJECT NUMBER :

DRAWING NUMBER :

SHEET SIZE


REV. NO.

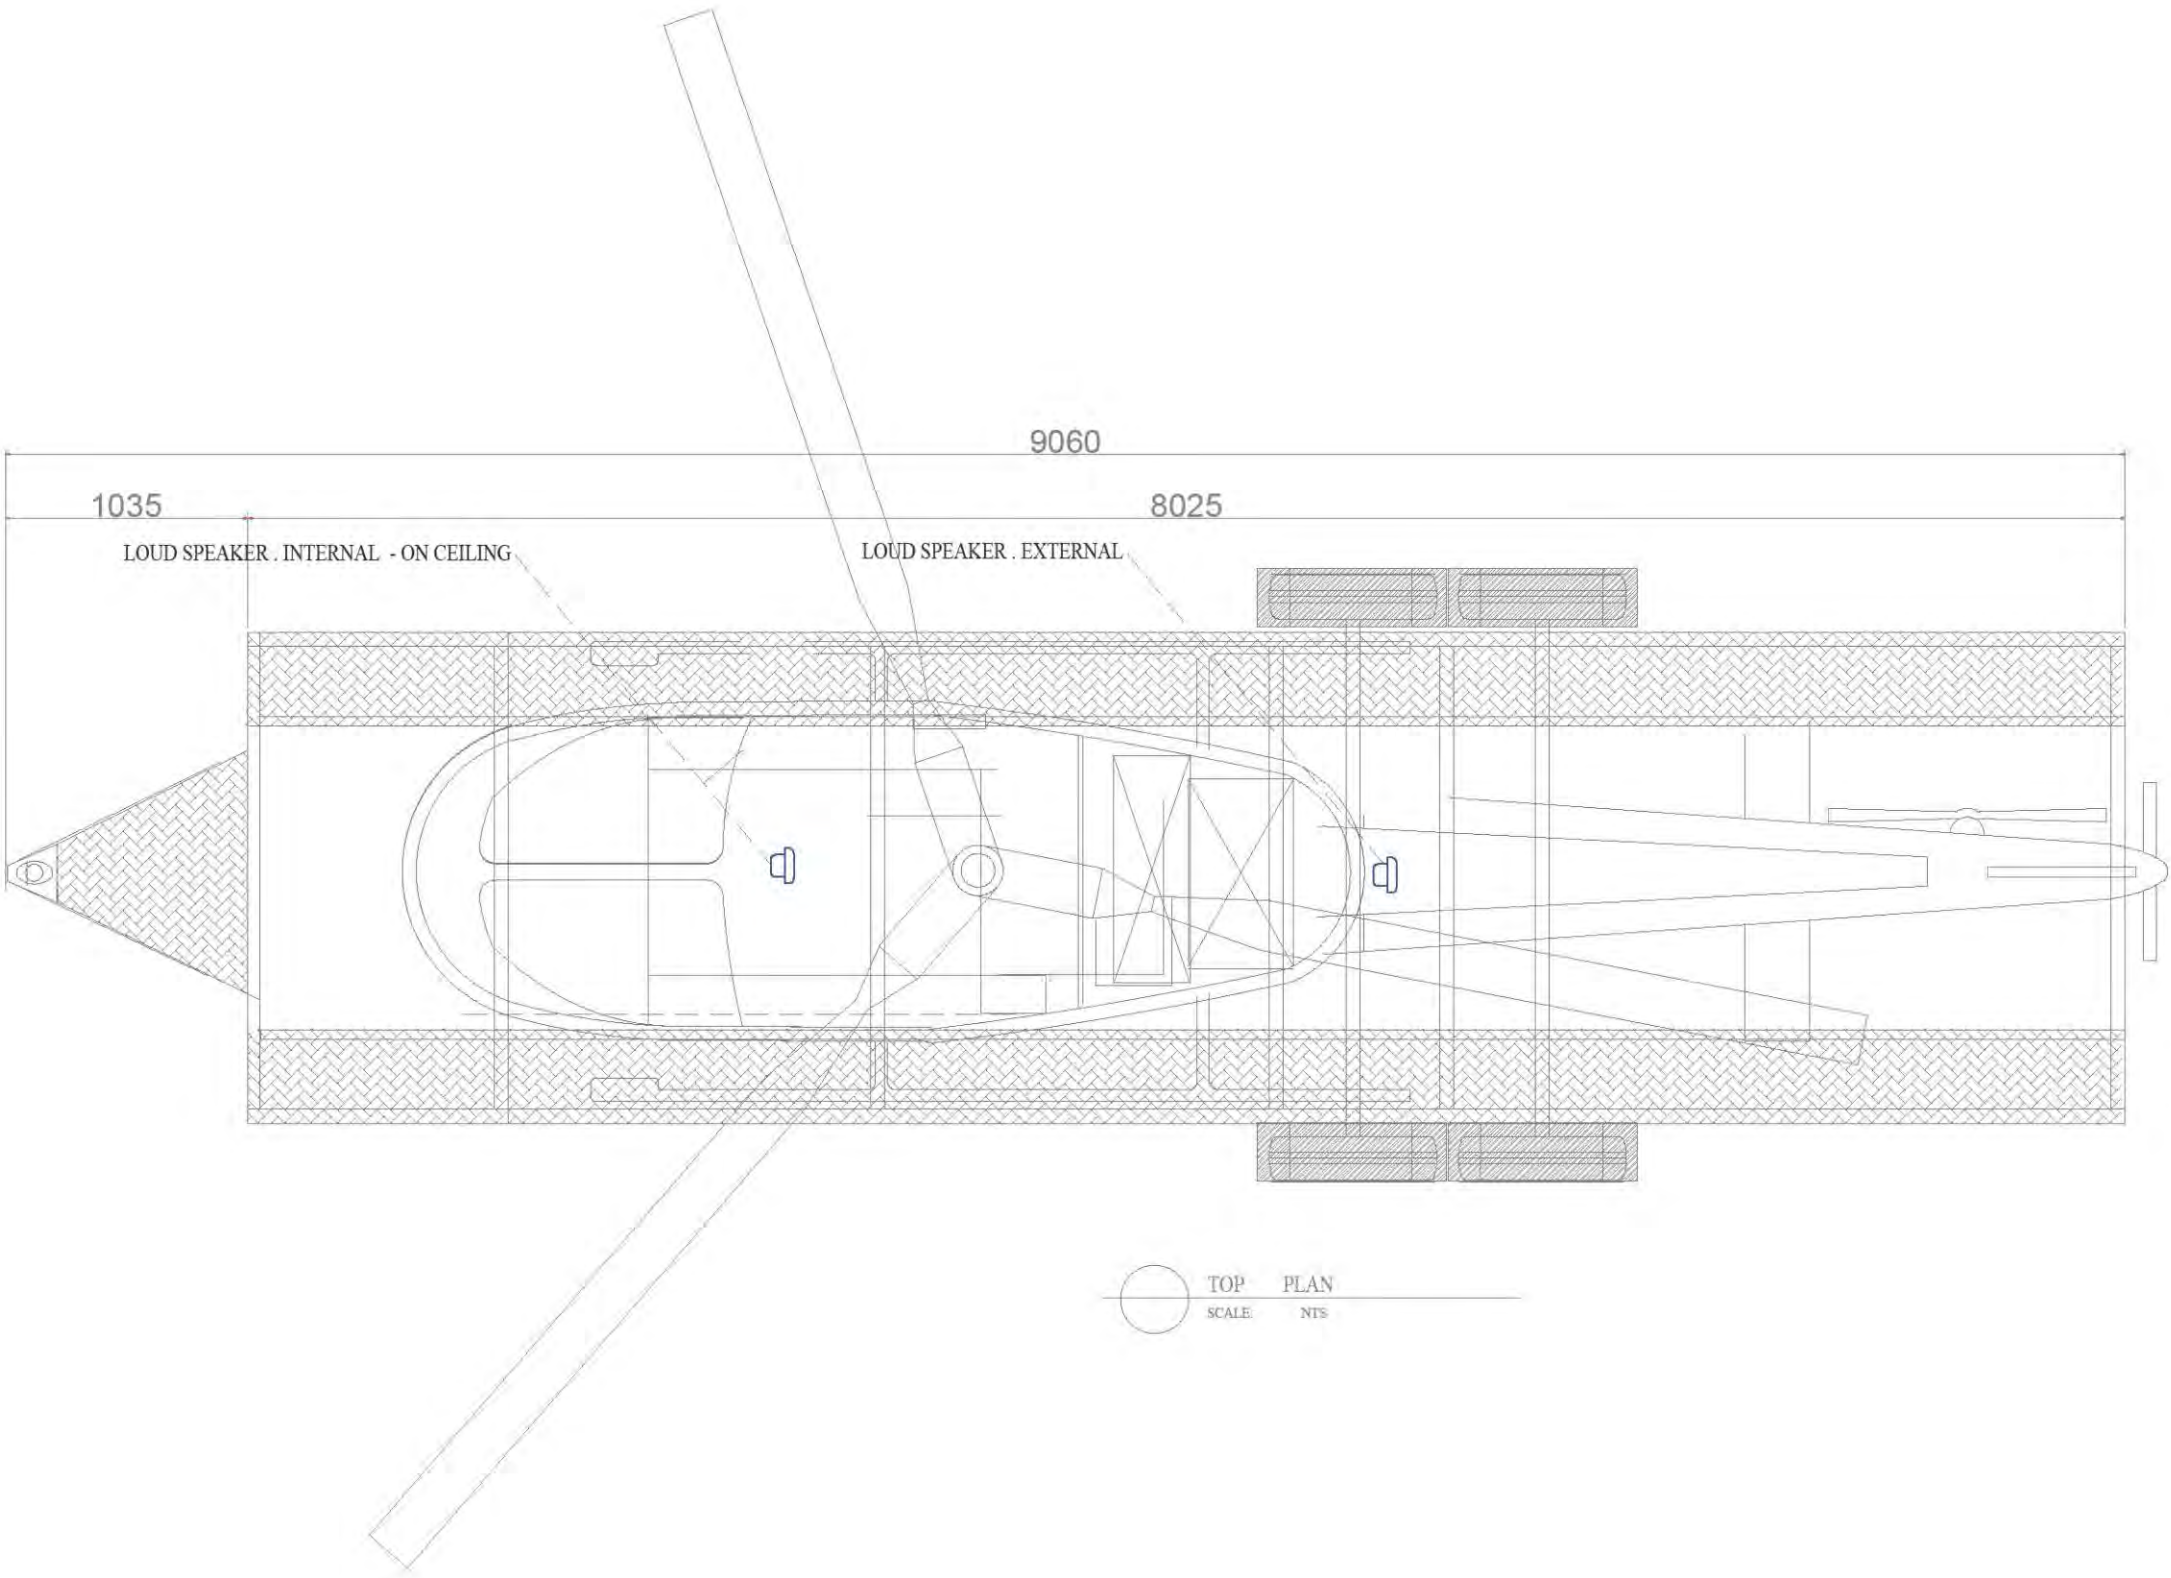

- NOTES:
- 1. THE COPYRIGHT OF THIS DRAWING IS VESTED IN "TVT TRAILERS MANUFACTURING LLC & THEFOODTRUCK.CO " NOT BE REPRODUCED IN WHOLE OR PART OR USED FOR THE MANUFACTURE OF ANY ARTICLE WITHOUT THE EXPRESS PERMISSION OF THE COPYRIGHT HOLDERS.
 - 2. WORK TO FIGURED DIMENSIONS ONLY.
 - 3. THIS DRAWING IS TO BE READ IN CONJUNCTION WITH ALL RELEVANT SERVICE ENGINEER'S AND PARTIES DRAWINGS AND SPECIFICATIONS.



R E V I S I O N S						
00		04-04-2021	AA	-	-	
00		INITIAL DRAWING	AA	-	-	
REV	DATE	DESCRIPTION	DRWN	CHKD	REV'D	
SCALE : METERS						
DESIGN & BUILD :						
CLIENT :						
HELICOPTER- DESERT ROCK						
PROJECT LOCATION :						
DUBAI - UAE						
DRAWING TITLE :			DWG TYPE			
SPEAKER LAYOUT PLAN						
PROJECT NUMBER :		DRAWING NUMBER :		SHEET SIZE		REV. NO.

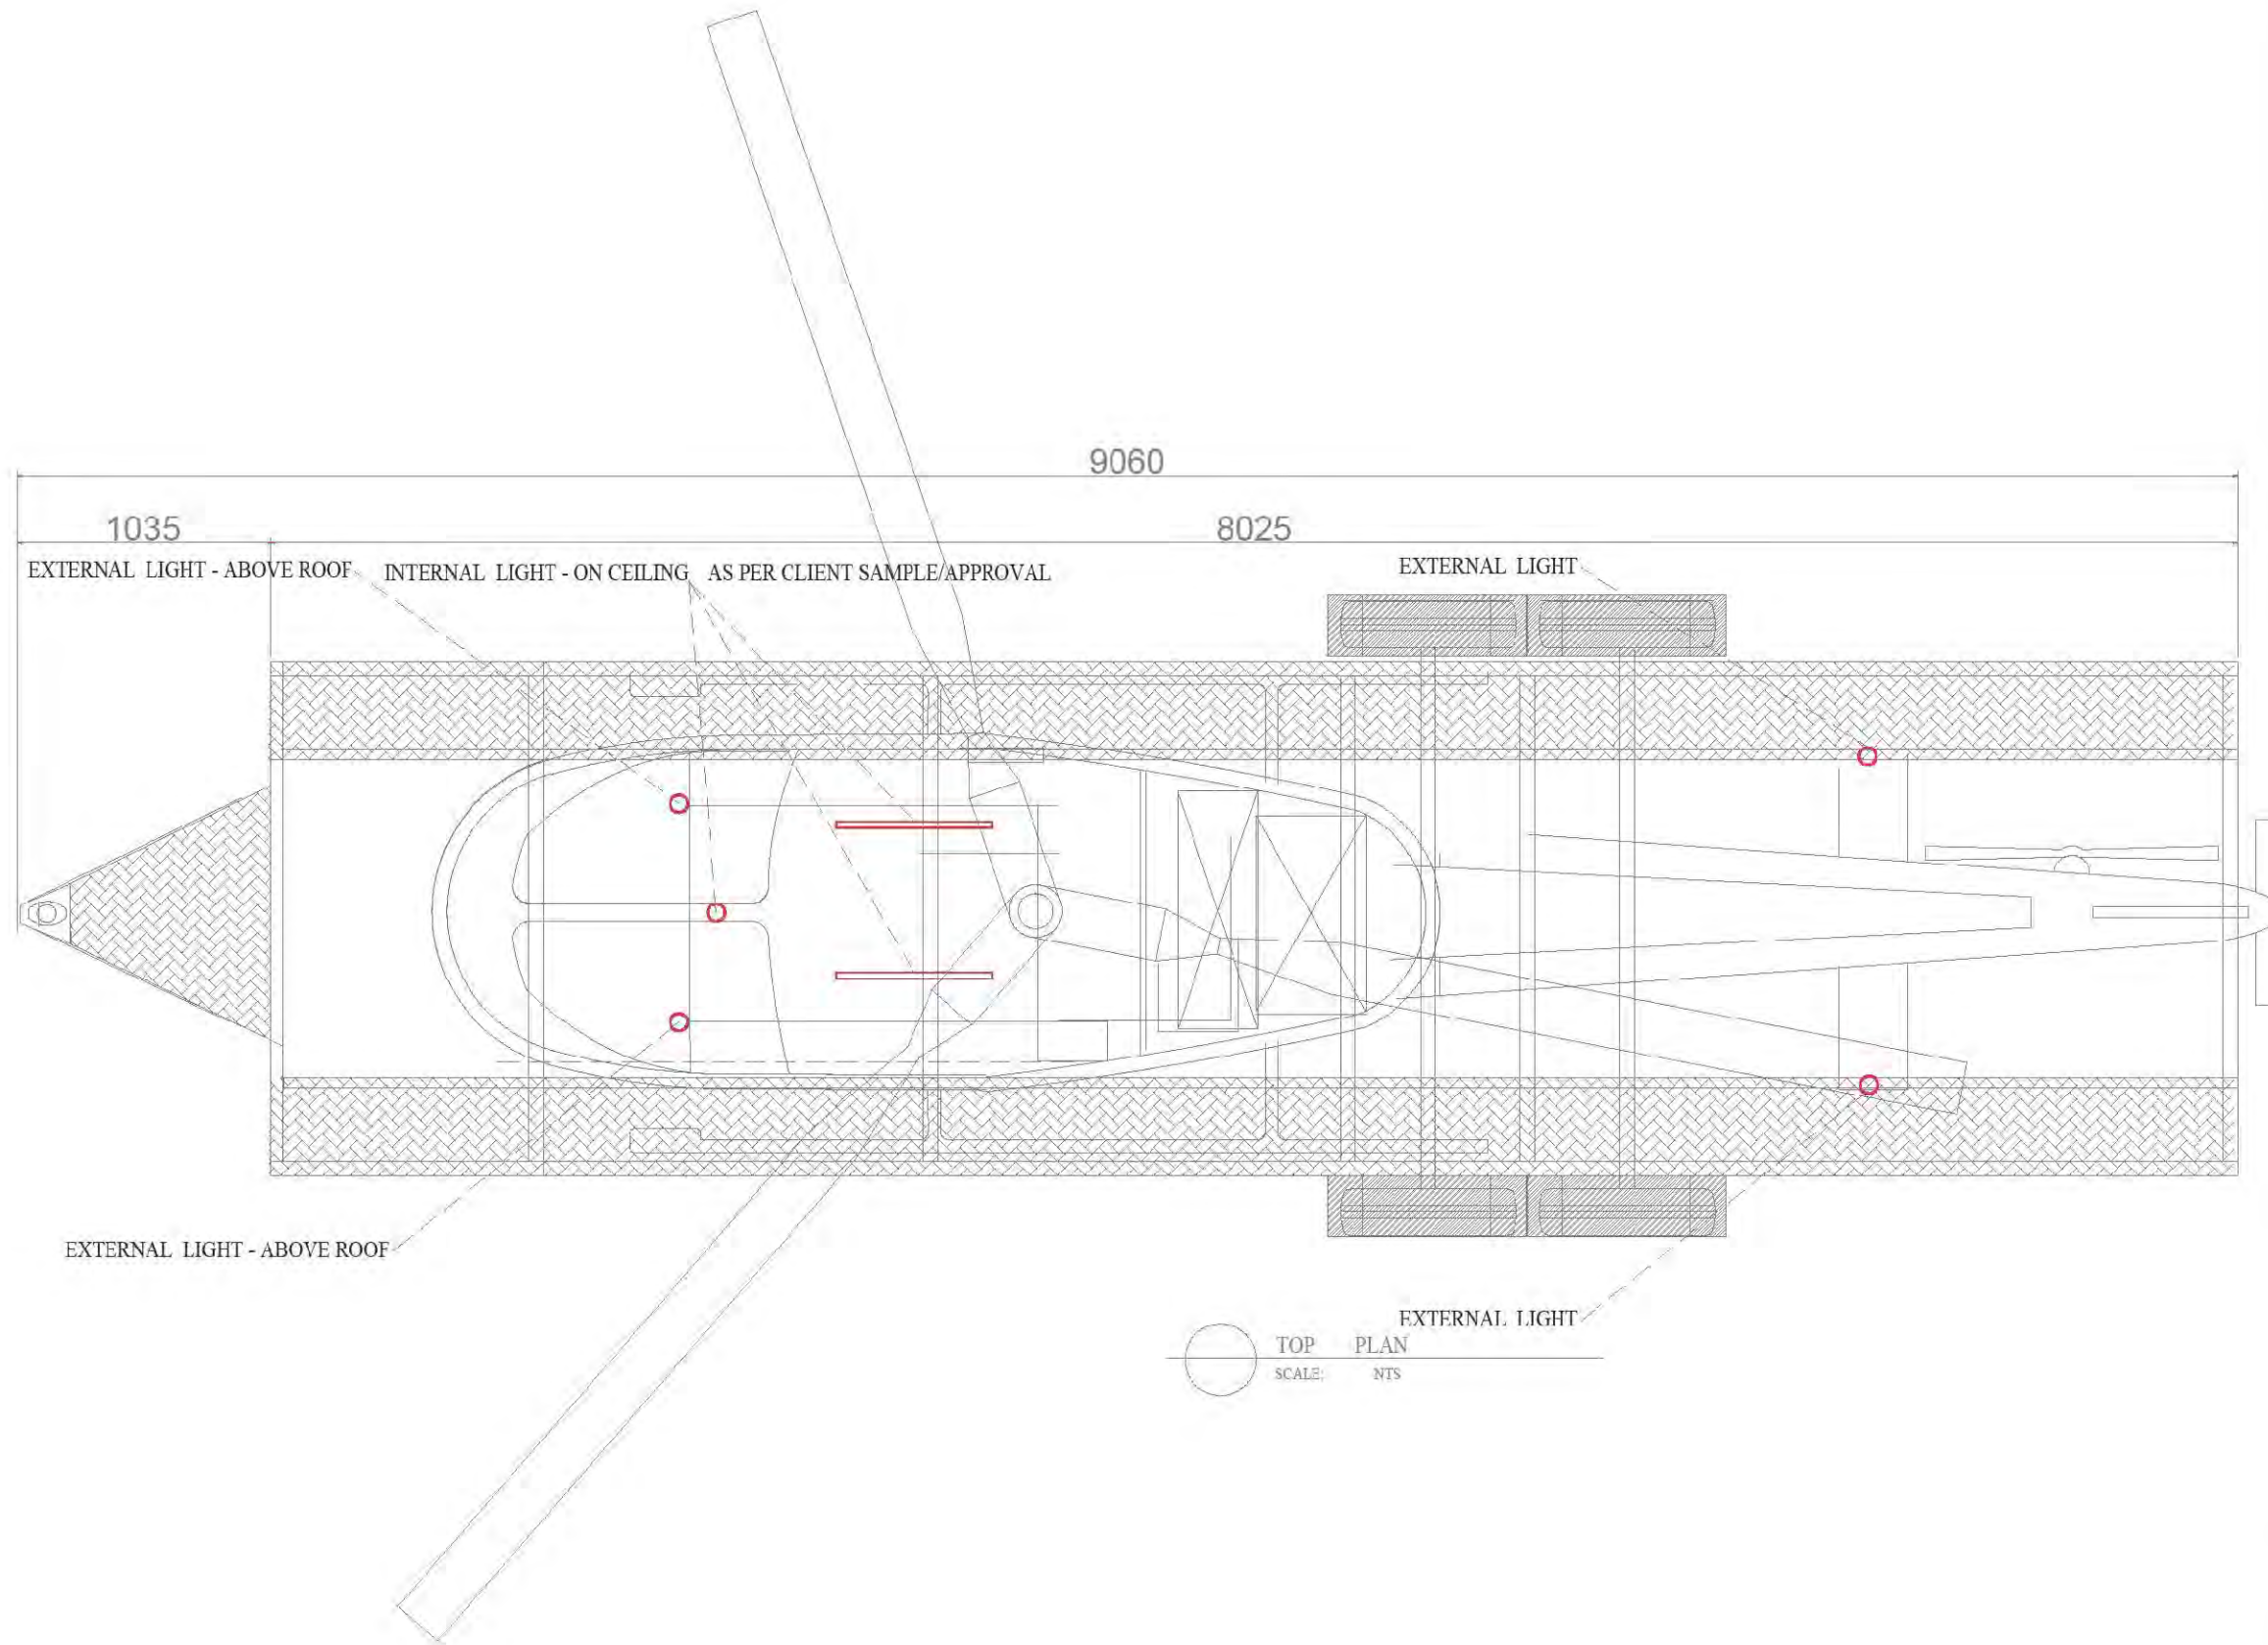

- NOTES:
1. THE COPYRIGHT OF THIS DRAWING IS VESTED IN "TVT TRAILERS MANUFACTURING LLC & THEFOODTRUCK.CO". NOT BE REPRODUCED IN WHOLE OR PART OR USED FOR THE MANUFACTURE OF ANY ARTICLE WITHOUT THE EXPRESS PERMISSION OF THE COPYRIGHT HOLDERS.
 2. WORK TO FIGURED DIMENSIONS ONLY.
 3. THIS DRAWING IS TO BE READ IN CONJUNCTION WITH ALL RELEVANT SERVICE ENGINEER'S AND PARTIES DRAWINGS AND SPECIFICATIONS.



R E V I S I O N S					
OC		04-04-2021	AA	-	-
OC		INITIAL DRAWING	AA	-	-
REV	DATE	DESCRIPTION	DRWN	CHKD	REVD

SCALE : METERS

DESIGN & BUILD :

CLIENT :

HELICOPTER-DESERT ROCK


PROJECT LOCATION :

DUBAI-UAE

DRAWING TITLE : DWG. TYPE


INTERNAL & EXTERNAL LIGHTING PLAN

PROJECT NUMBER : DRAWING NUMBER : SHEET SIZE REV. NO.

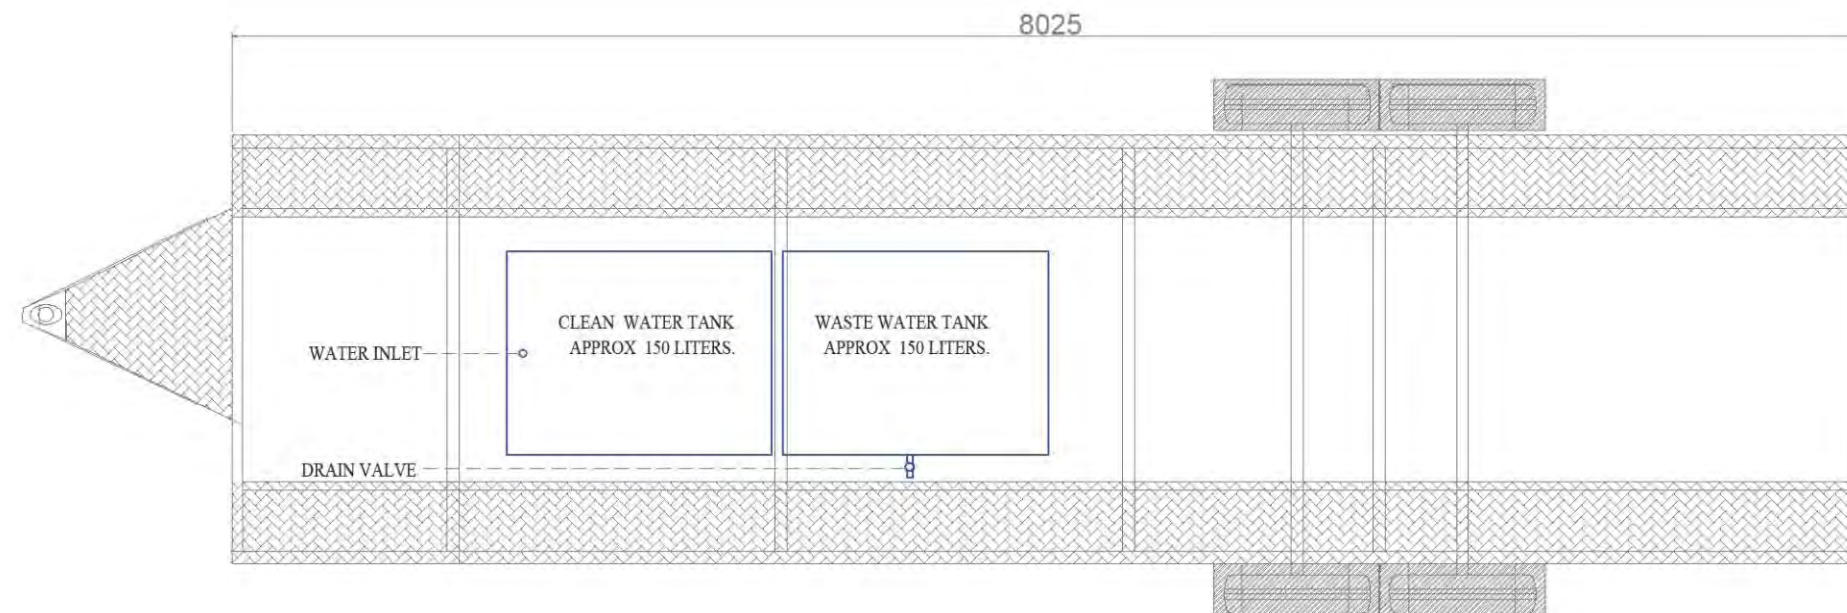

TRAILER PLAN DTL.
SCALE: NTS

NOTE: ALL PIPING CONNECTIONS ARE CONCEALED

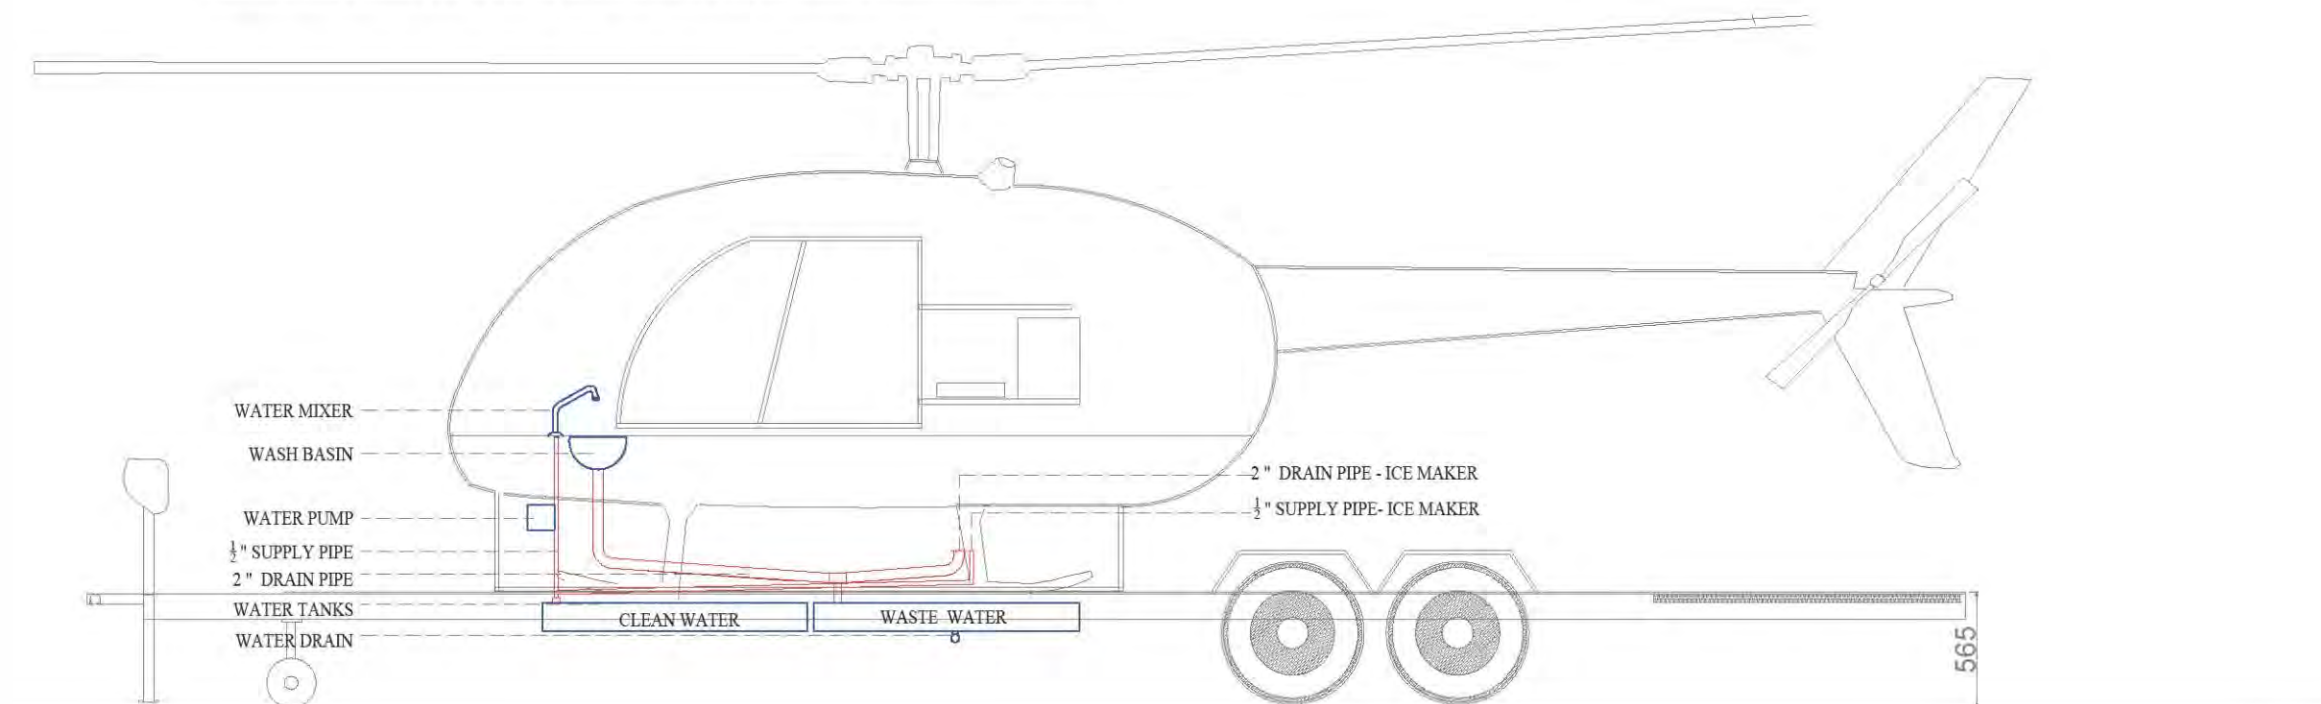

ELEVATION DTL.
SCALE: NTS

NOTES:

1. THE COPYRIGHT OF THIS DRAWING IS VESTED IN "TVT TRAILERS MANUFACTURING LLC & THEFOODTRUCK.CO " NOT BE REPRODUCED IN WHOLE OR PART OR USED FOR THE MANUFACTURE OF ANY ARTICLE WITHOUT THE EXPRESS PERMISSION OF THE COPYRIGHT HOLDERS.
2. WORK TO FIGURED DIMENSIONS ONLY.
3. THIS DRAWING IS TO BE READ IN CONJUNCTION WITH ALL RELEVANT SERVICE ENGINEER'S AND PARTIES DRAWINGS AND SPECIFICATIONS.



REVISIONS

REV	DATE	DESCRIPTION	DRWN	CHKD	REVD
	07-04-2021		AA		
	04-04-2021		AA	-	-
		INITIAL DRAWING	AA	-	-

SCALE : _____ METERS

DESIGN & BUILD :

CLIENT :

HELICOPTER - DESERT ROCK

PROJECT LOCATION :

DUBAI - UAE

DRAWING TITLE :

PLUMBING PLAN


DWG. TYPE

PROJECT NUMBER :

DRAWING NUMBER :

SHEET SIZE


REV. NO.

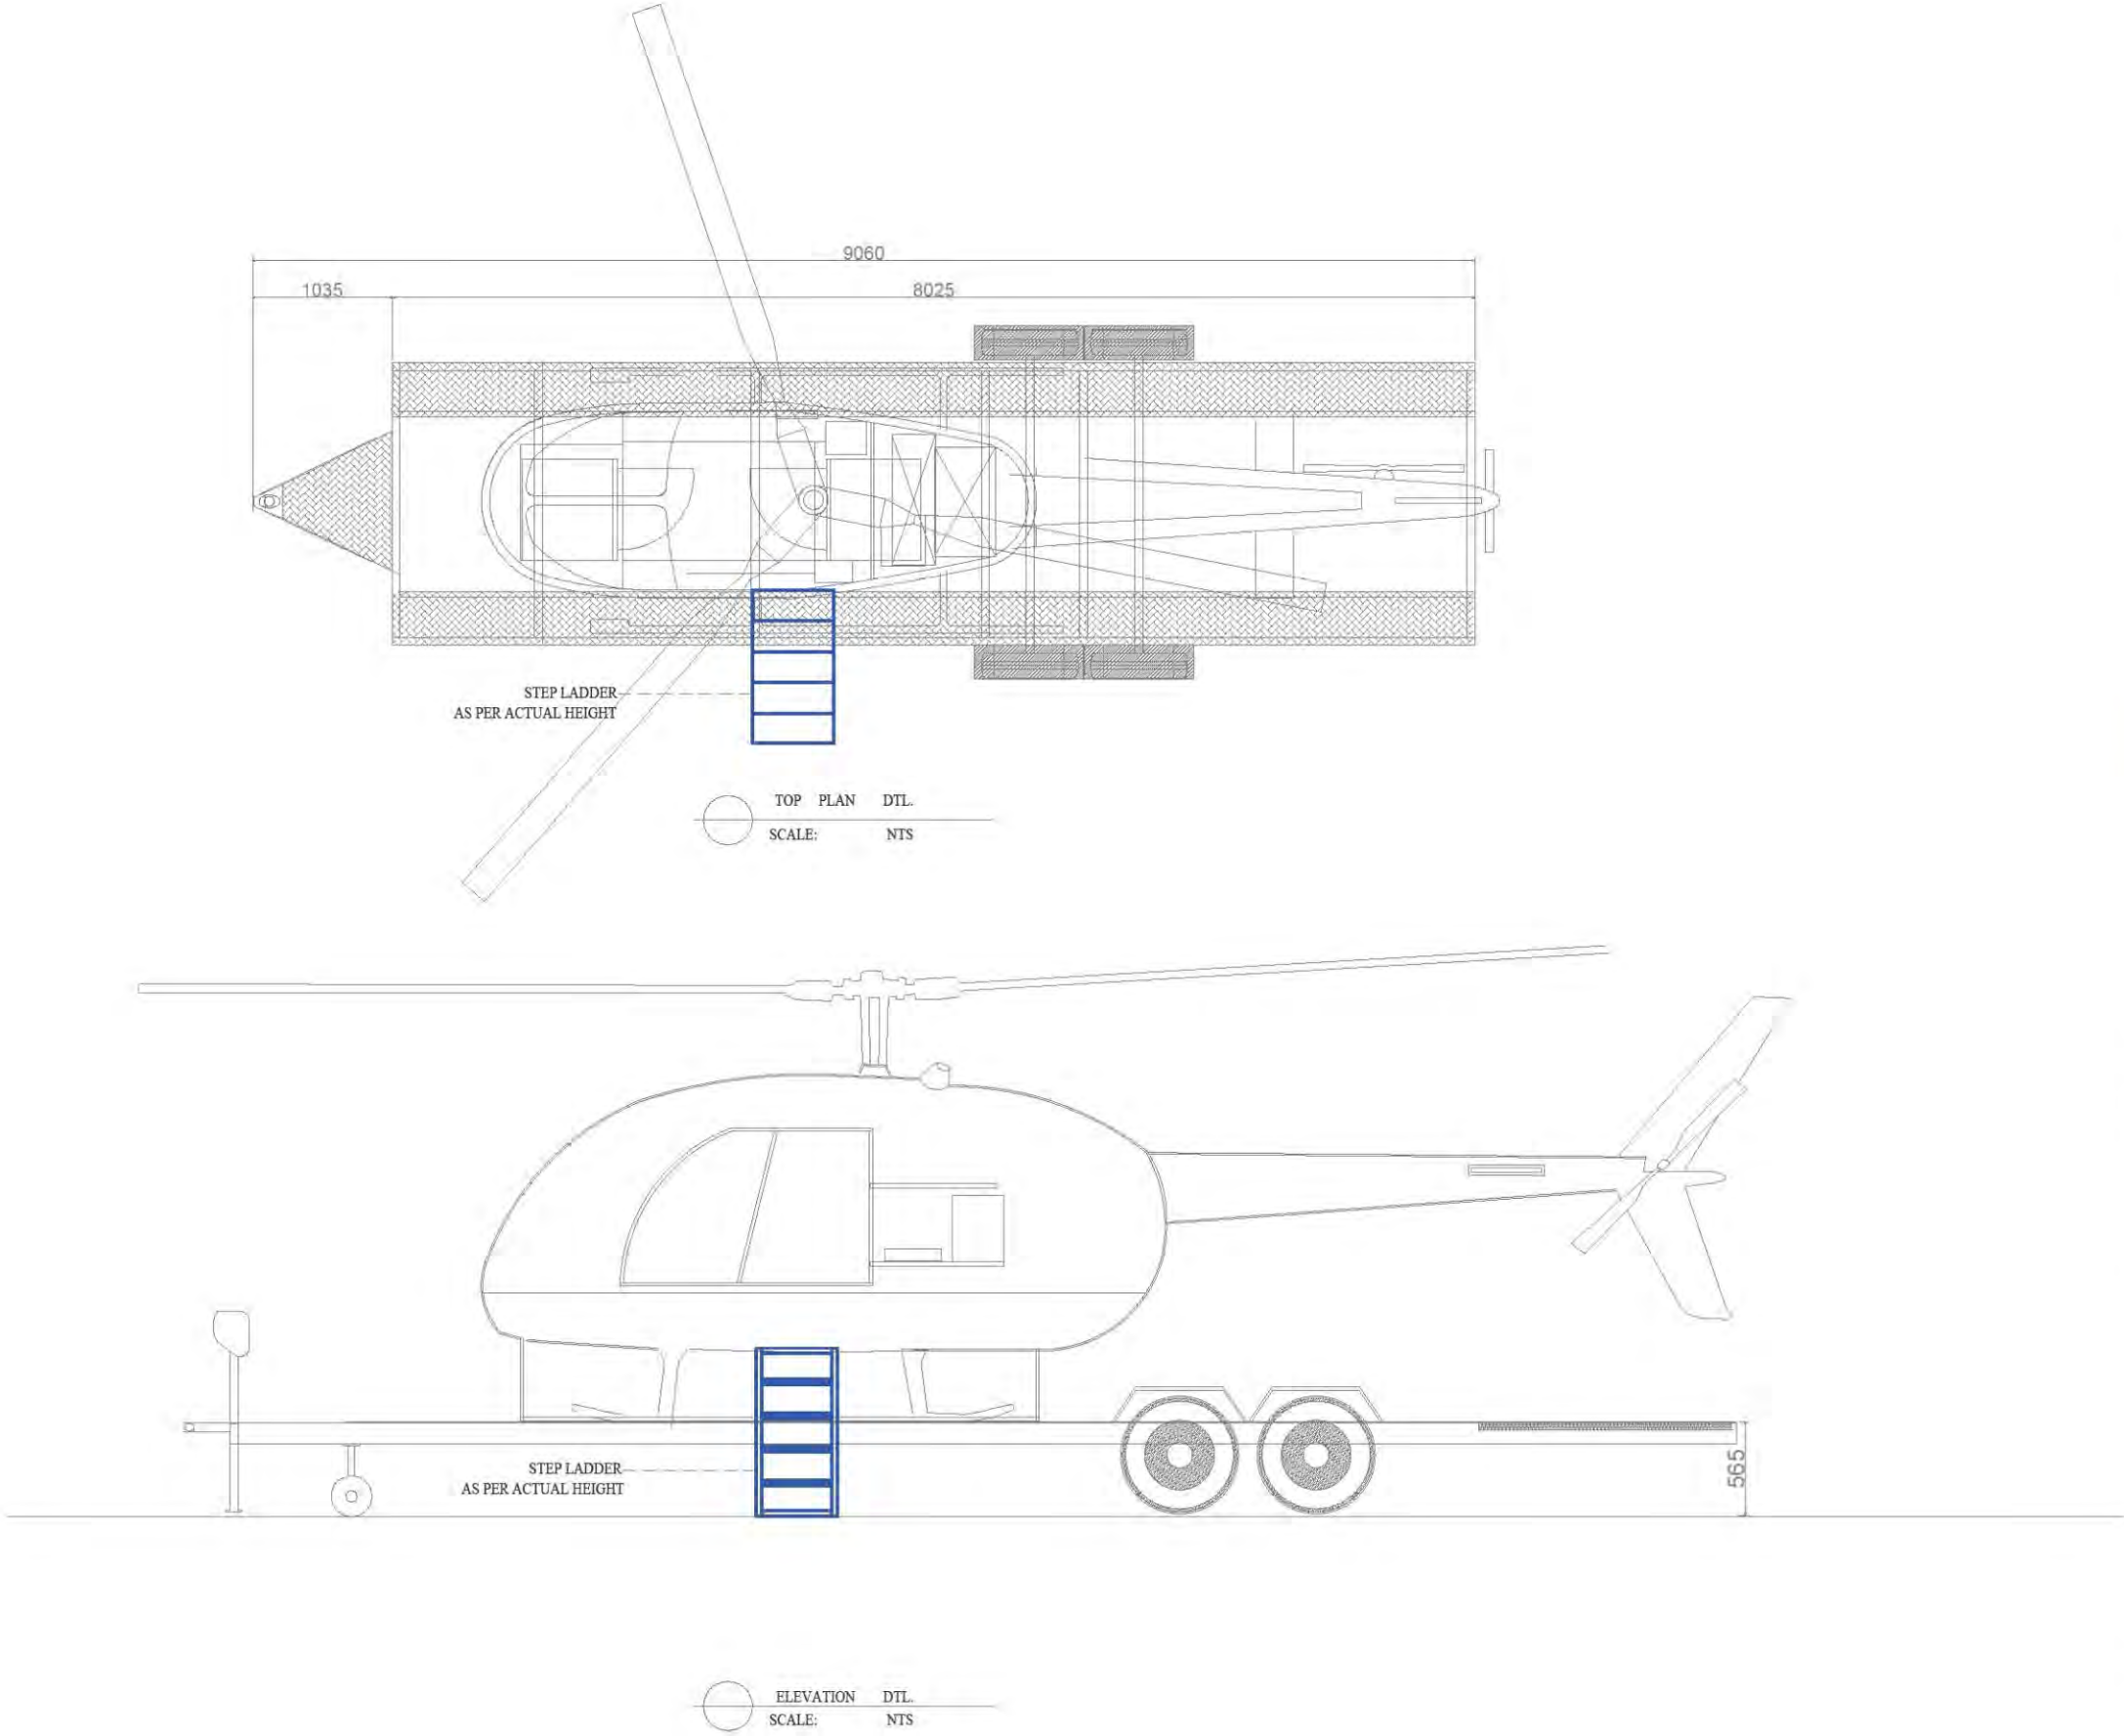

- NOTES:
1. THE COPYRIGHT OF THIS DRAWING IS VESTED IN "TVT TRAILERS MANUFACTURING LLC & THEFOODTRUCK.CO " NOT BE REPRODUCED IN WHOLE OR PART OR USED FOR THE MANUFACTURE OF ANY ARTICLE WITHOUT THE EXPRESS PERMISSION OF THE COPYRIGHT HOLDERS.
 2. WORK TO FIGURED DIMENSIONS ONLY.
 3. THIS DRAWING IS TO BE READ IN CONJUNCTION WITH ALL RELEVANT SERVICE ENGINEER'S AND PARTIES DRAWINGS AND SPECIFICATIONS.




REVISIONS						
DD	07-04-2021	AA				
DD	INITIAL DRAWING	AA	-	-	-	-
REV	DATE	DESCRIPTION	DRWN	CHKD	REVD	
SCALE : METERS						
DESIGN & BUILD :						
CLIENT :						
HELICOPTER - DESERT ROCK						
PROJECT LOCATION :						
DUBAI - UAE						
DRAWING TITLE :					DWG. TYPE	
STEP LADDER & ELEVATION						
PROJECT NUMBER :		DRAWING NUMBER :		SHEET SIZE	REV. NO.	

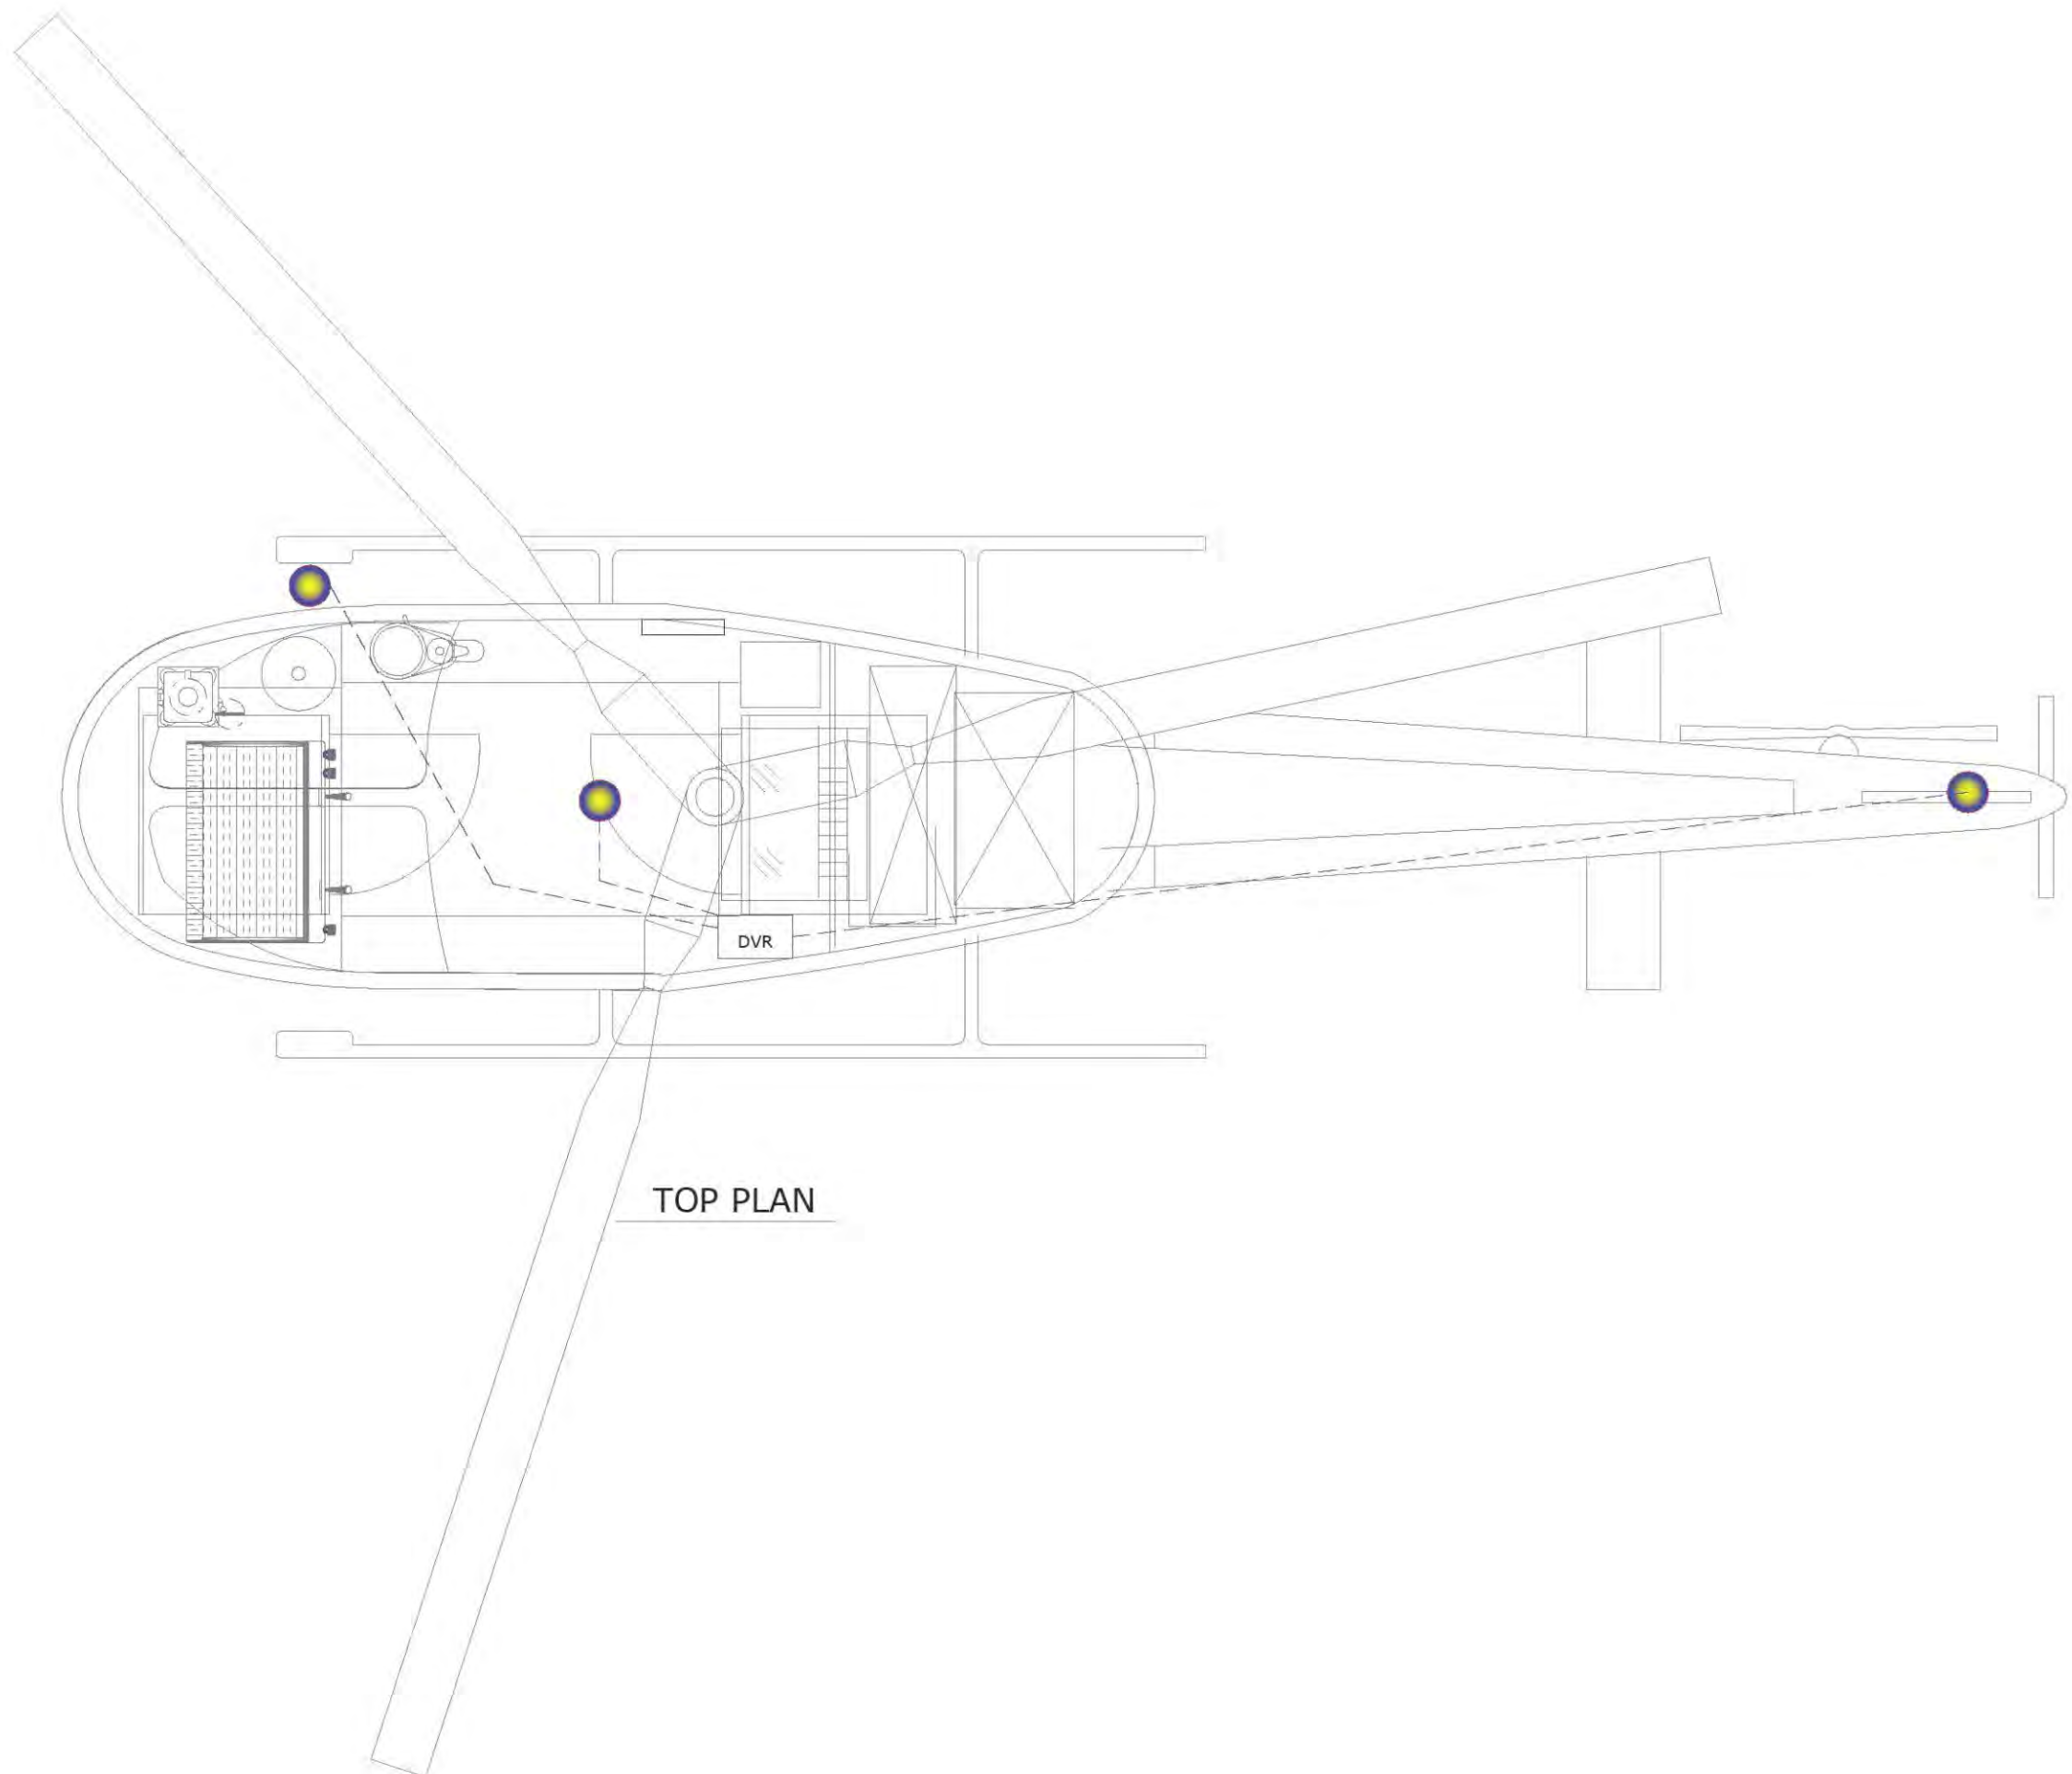

- NOTES:
1. THE COPYRIGHT OF THIS DRAWING IS VESTED IN "THE FOODSTERS & MANUFACUTING THE FOODTRUCK.CO" NOT BE REPRODUCED IN WHOLE OR PART OR USED FOR THE MANUFACTURE OF ANY ARTICLE WITHOUT THE EXPRESS PERMISSION OF THE COPYRIGHT HOLDERS.
 2. WORK TO FIGURED DIMENSIONS ONLY.
 3. THIS DRAWING IS TO BE READ IN CONJUNCTION WITH ALL RELEVANT SERVICE ENGINEER'S AND PARTIES DRAWINGS AND SPECIFICATIONS.




R E V I S I O N S						
	04.04.21			AA		
	23.02.21			AA		
	07.01.21	INITIAL DRAWING		AA		-
REV	DATE	DESCRIPTION	DRWN	CHKD	REVD	
SCALE : METERS						
DESIGN & BUILD :						
CLIENT :						
HELICOPTER - DESERT ROCK						
PROJECT LOCATION :						
UAE						
DRAWING TITLE :				DWG. TYPE		
CAMERA/CCTV PLAN						
PROJECT NUMBER :		DRAWING NUMBER :		SHEET SIZE		REV. NO.
				A3		

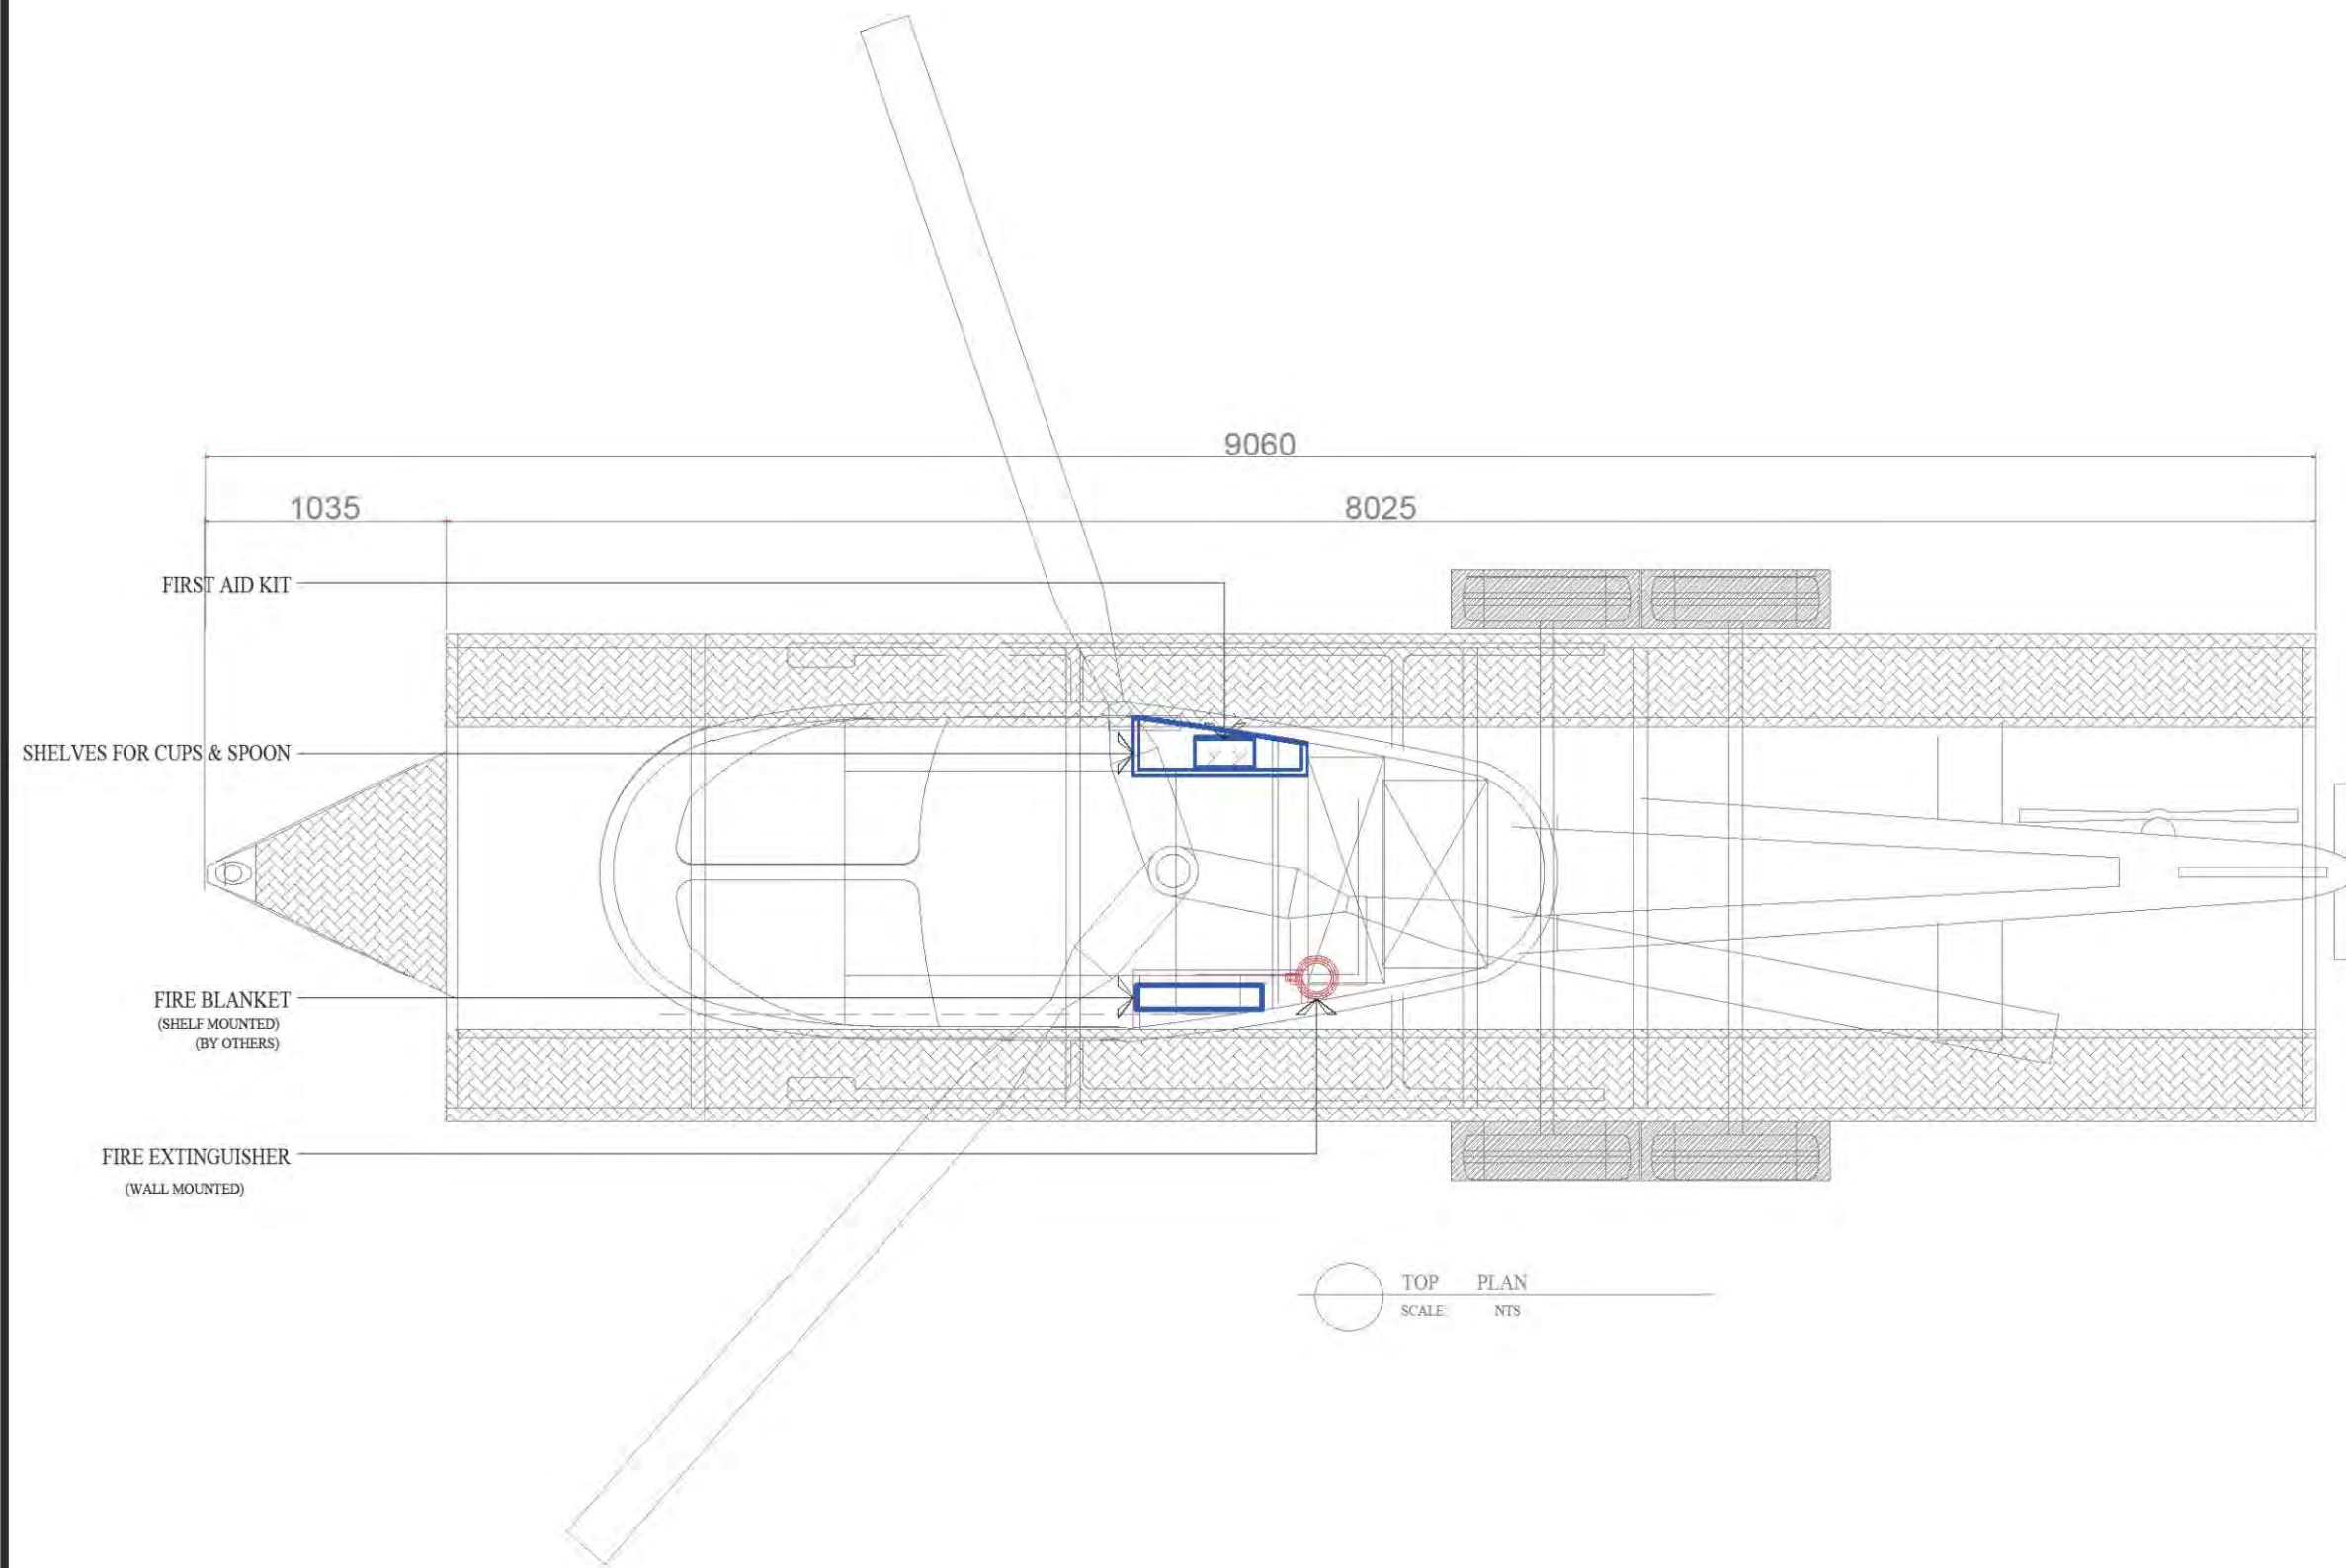

- NOTES:
1. THE COPYRIGHT OF THIS DRAWING IS VESTED IN "TVT TRAILERS MANUFACTURING LLC & THEFOODTRUCK.CO " NOT BE REPRODUCED IN WHOLE OR PART OR USED FOR THE MANUFACTURE OF ANY ARTICLE WITHOUT THE EXPRESS PERMISSION OF THE COPYRIGHT HOLDERS.
 2. WORK TO FIGURED DIMENSIONS ONLY.
 3. THIS DRAWING IS TO BE READ IN CONJUNCTION WITH ALL RELEVANT SERVICE ENGINEER'S AND PARTIES DRAWINGS AND SPECIFICATIONS.



R E V I S I O N S					
00		11-04-2021	AA	-	-
00		INITIAL DRAWING	AA	-	-
REV	DATE	DESCRIPTION	DRWN	CHKD	REVD
SCALE : METERS					
DESIGN & BUILD :					
CLIENT :					
HELICOPTER- DESERT ROCK					
PROJECT LOCATION :					
DUBAI - UAE					
DRAWING TITLE :			DWG. TYPE		
FIRE EXTINGUISHER & FIRE BLANKET					
PROJECT NUMBER :	DRAWING NUMBER :	SHEET SIZE	REV. NO.		

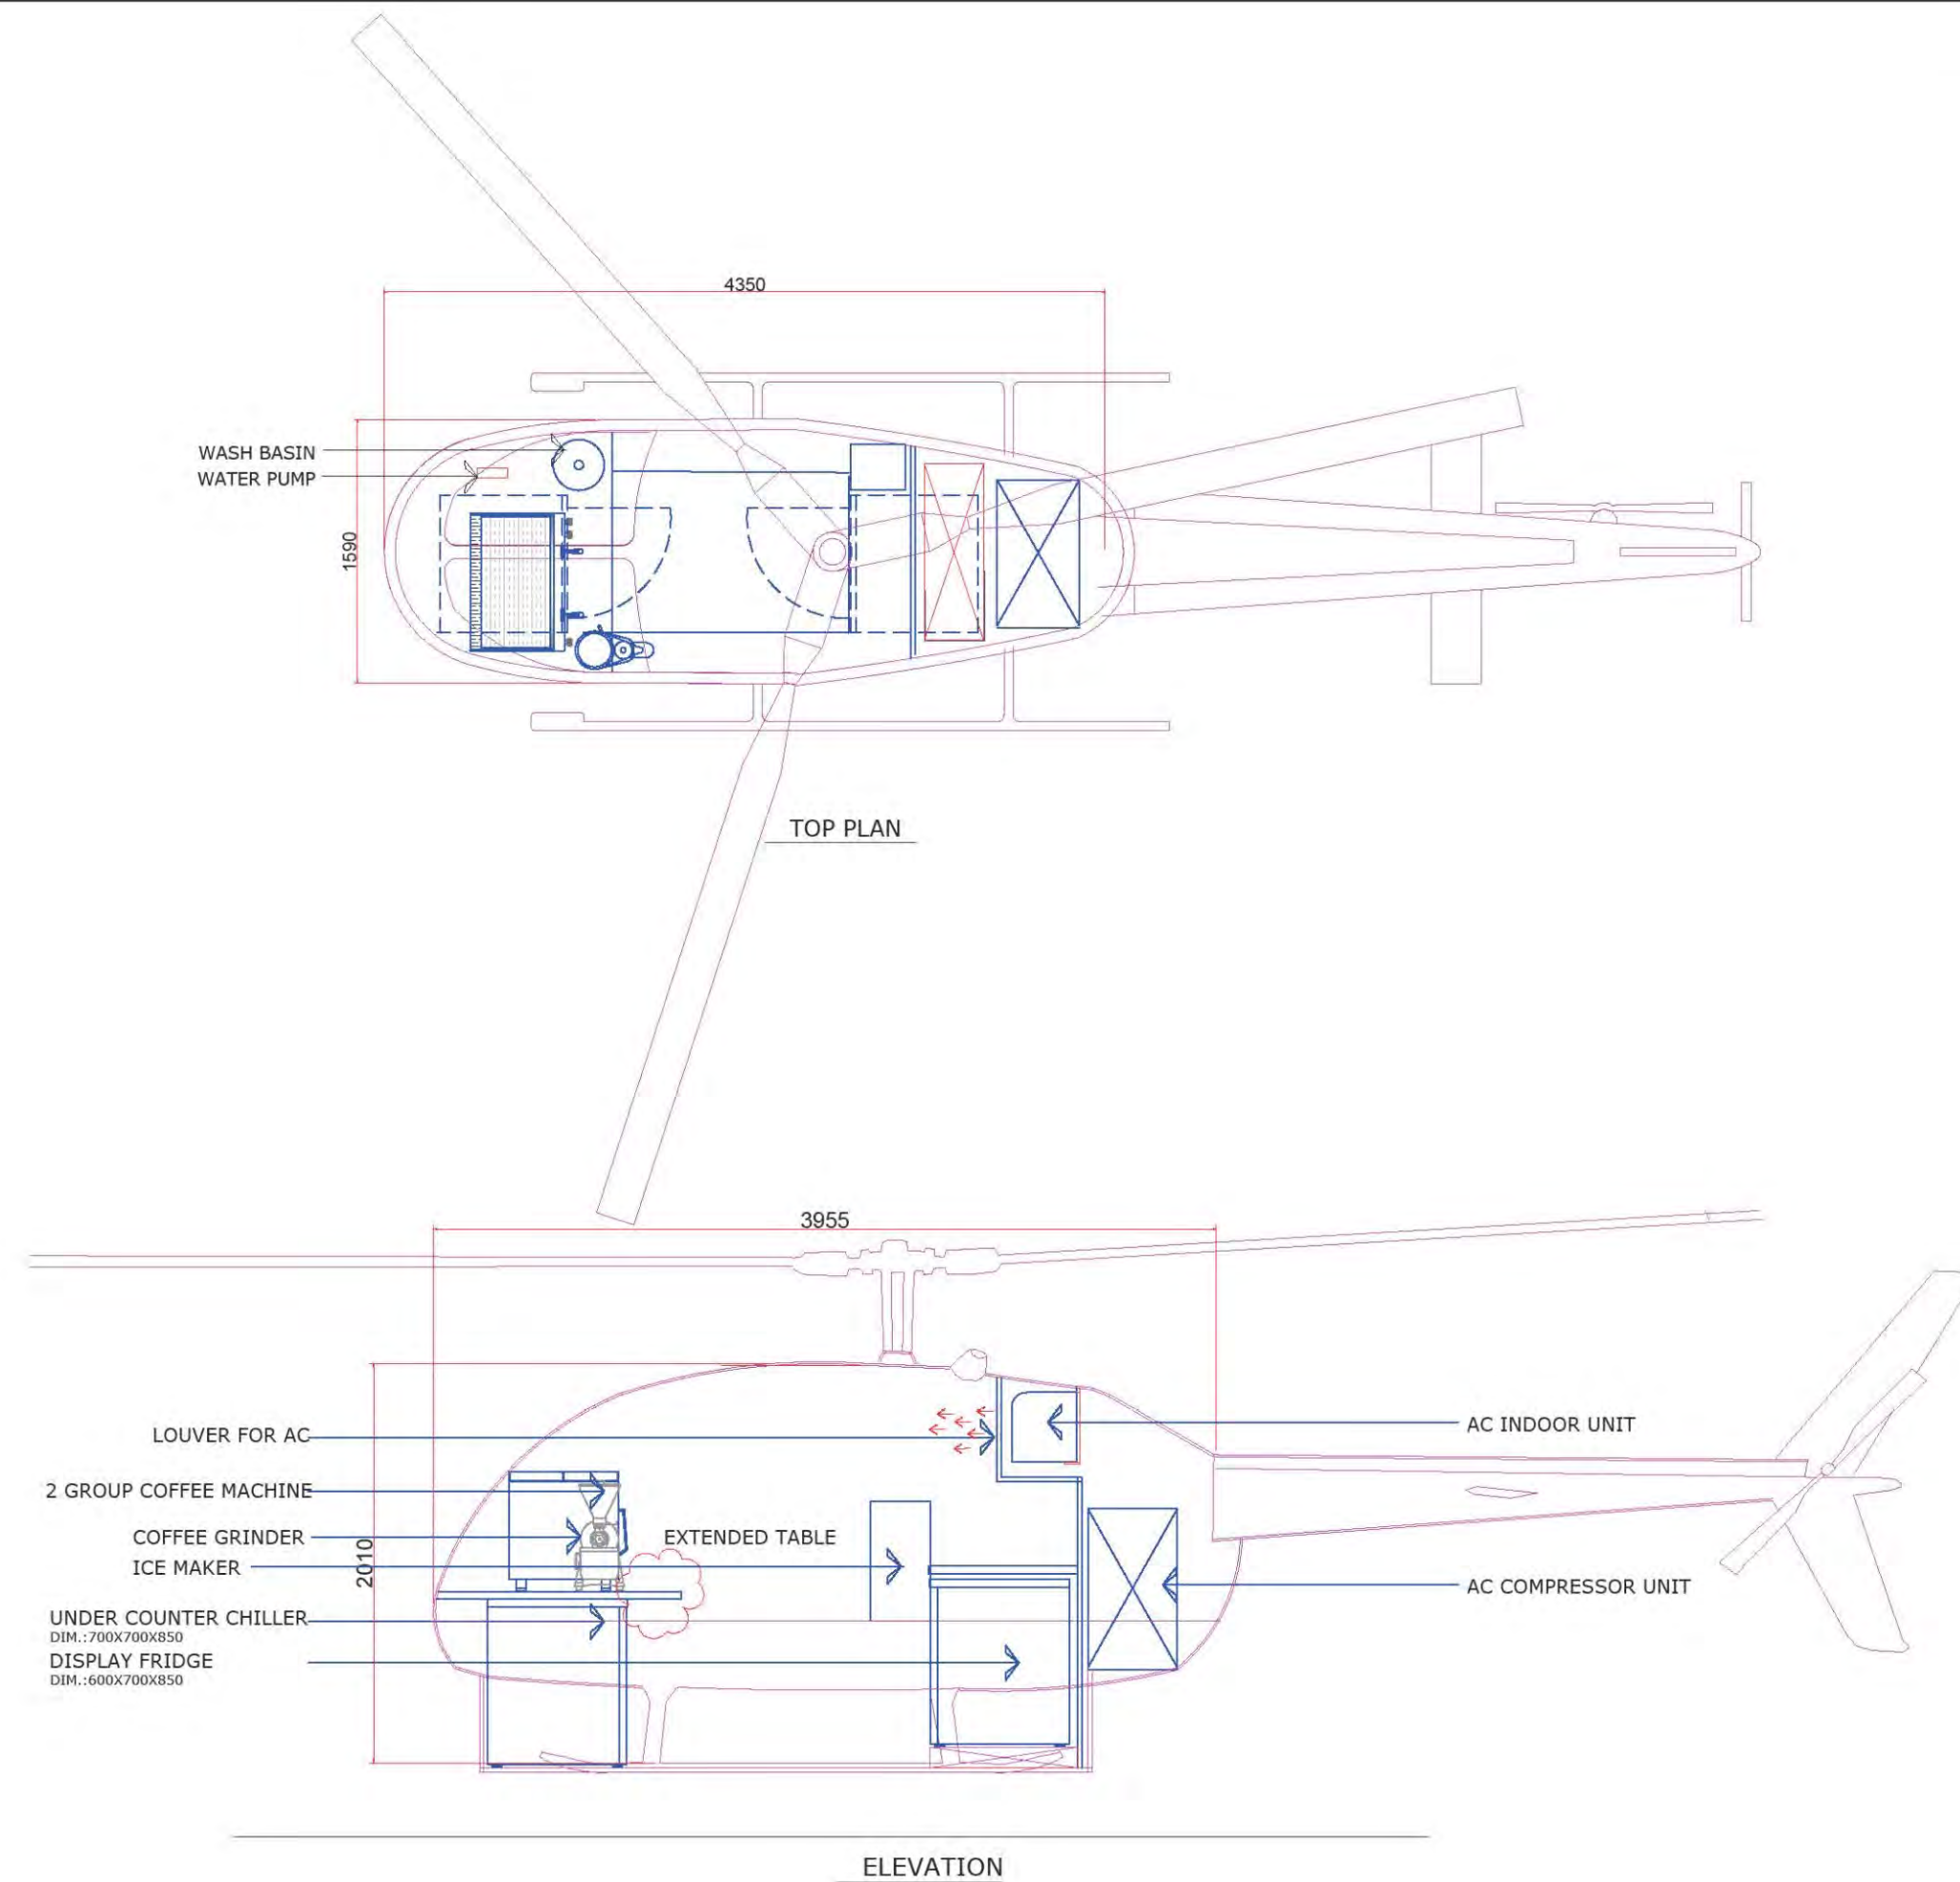

NOTES:


1. THE COPYRIGHT OF THIS DRAWING IS VESTED IN "THE FOODSTERS & MANUFACTURING THE FOODTRUCK.CO" NOT BE REPRODUCED IN WHOLE OR PART OR USED FOR THE MANUFACTURE OF ANY ARTICLE WITHOUT THE EXPRESS PERMISSION OF THE COPYRIGHT HOLDERS.

2. WORK TO FIGURED DIMENSIONS ONLY.

3. THIS DRAWING IS TO BE READ IN CONJUNCTION WITH ALL RELEVANT SERVICE ENGINEER'S AND PARTIES DRAWINGS AND SPECIFICATIONS.




R E V I S I O N S					
	04.04.21	REV.2	AA		
	06.02.21		AA		
00	07.01.21	INITIAL DRAWING	AA		--
REV	DATE	DESCRIPTION	DRWN	CHKD	REVO
SCALE : _____ METERS					
DESIGN & BUILD :					
CLIENT :					
HELICOPTER COFFEE CONCEPT					
PROJECT LOCATION :					
UAE					
DRAWING TITLE :			DWG. TYPE		
LAYOUT PLAN & ELEVATION					
PROJECT NUMBER :		DRAWING NUMBER :		SHEET SIZE	REV. NO.
				A3	

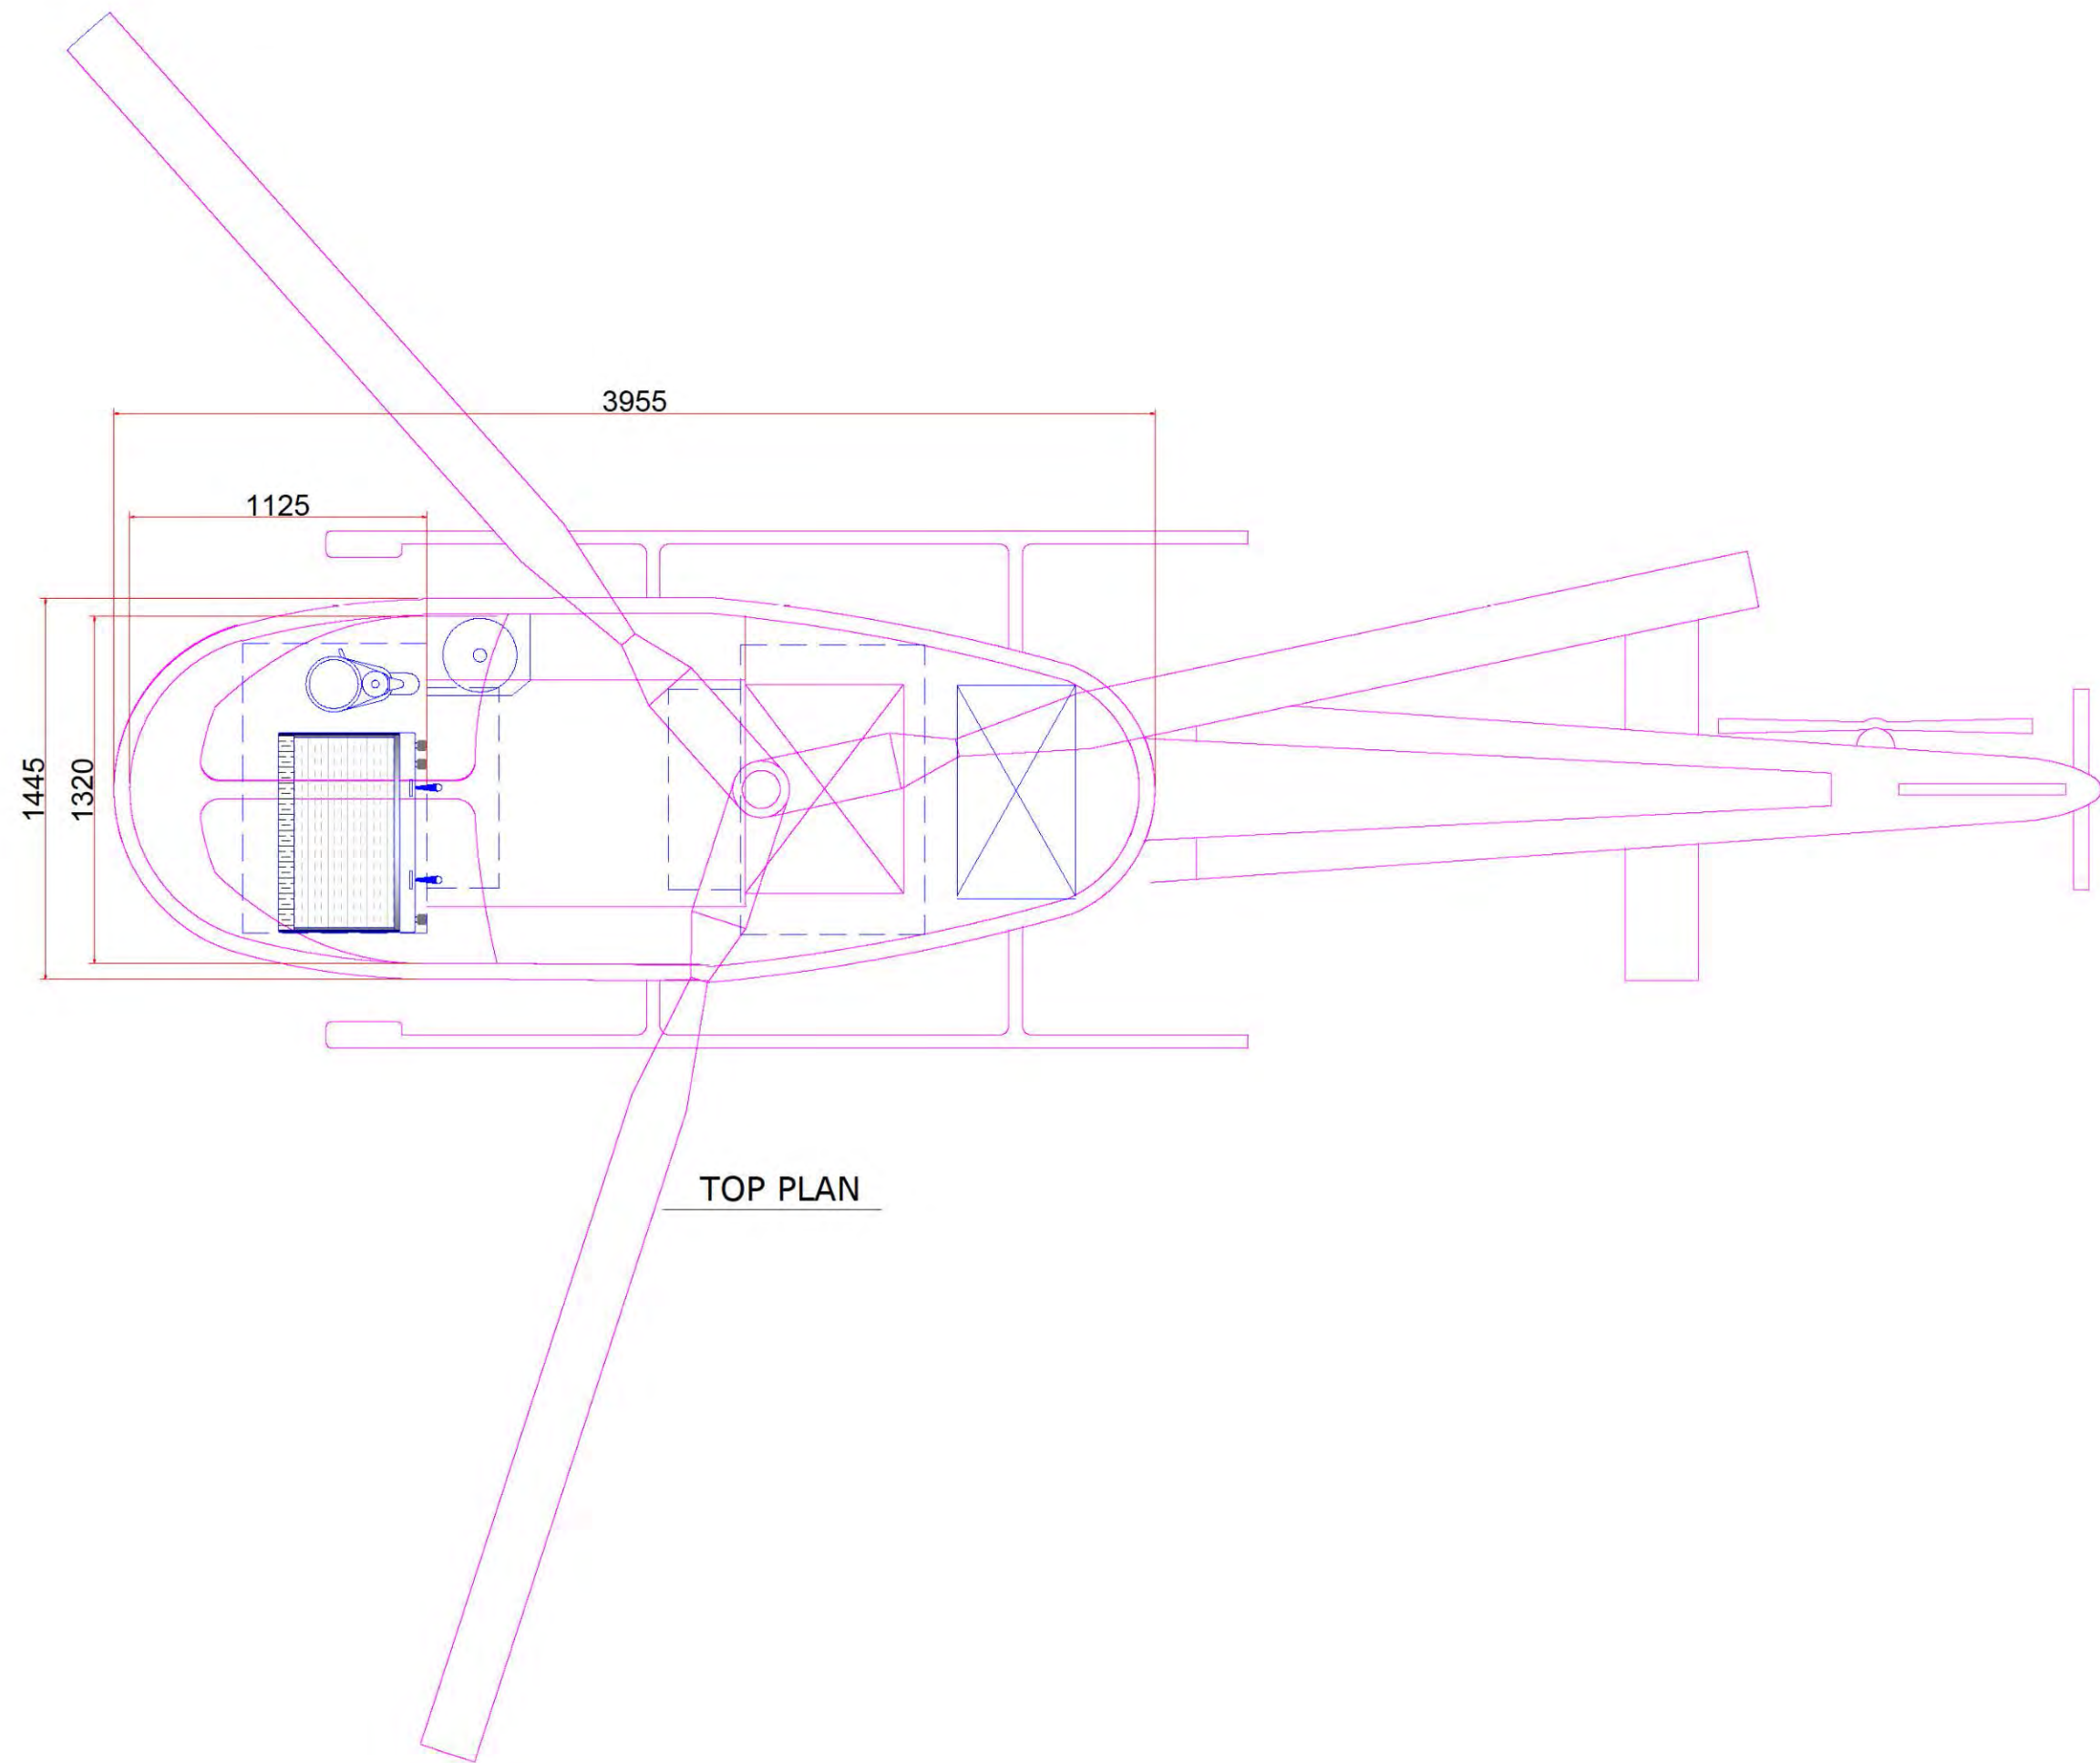

TOP PLAN

Background Clear acrylic sheet

Acrylic sheet fix with 19mm knobs

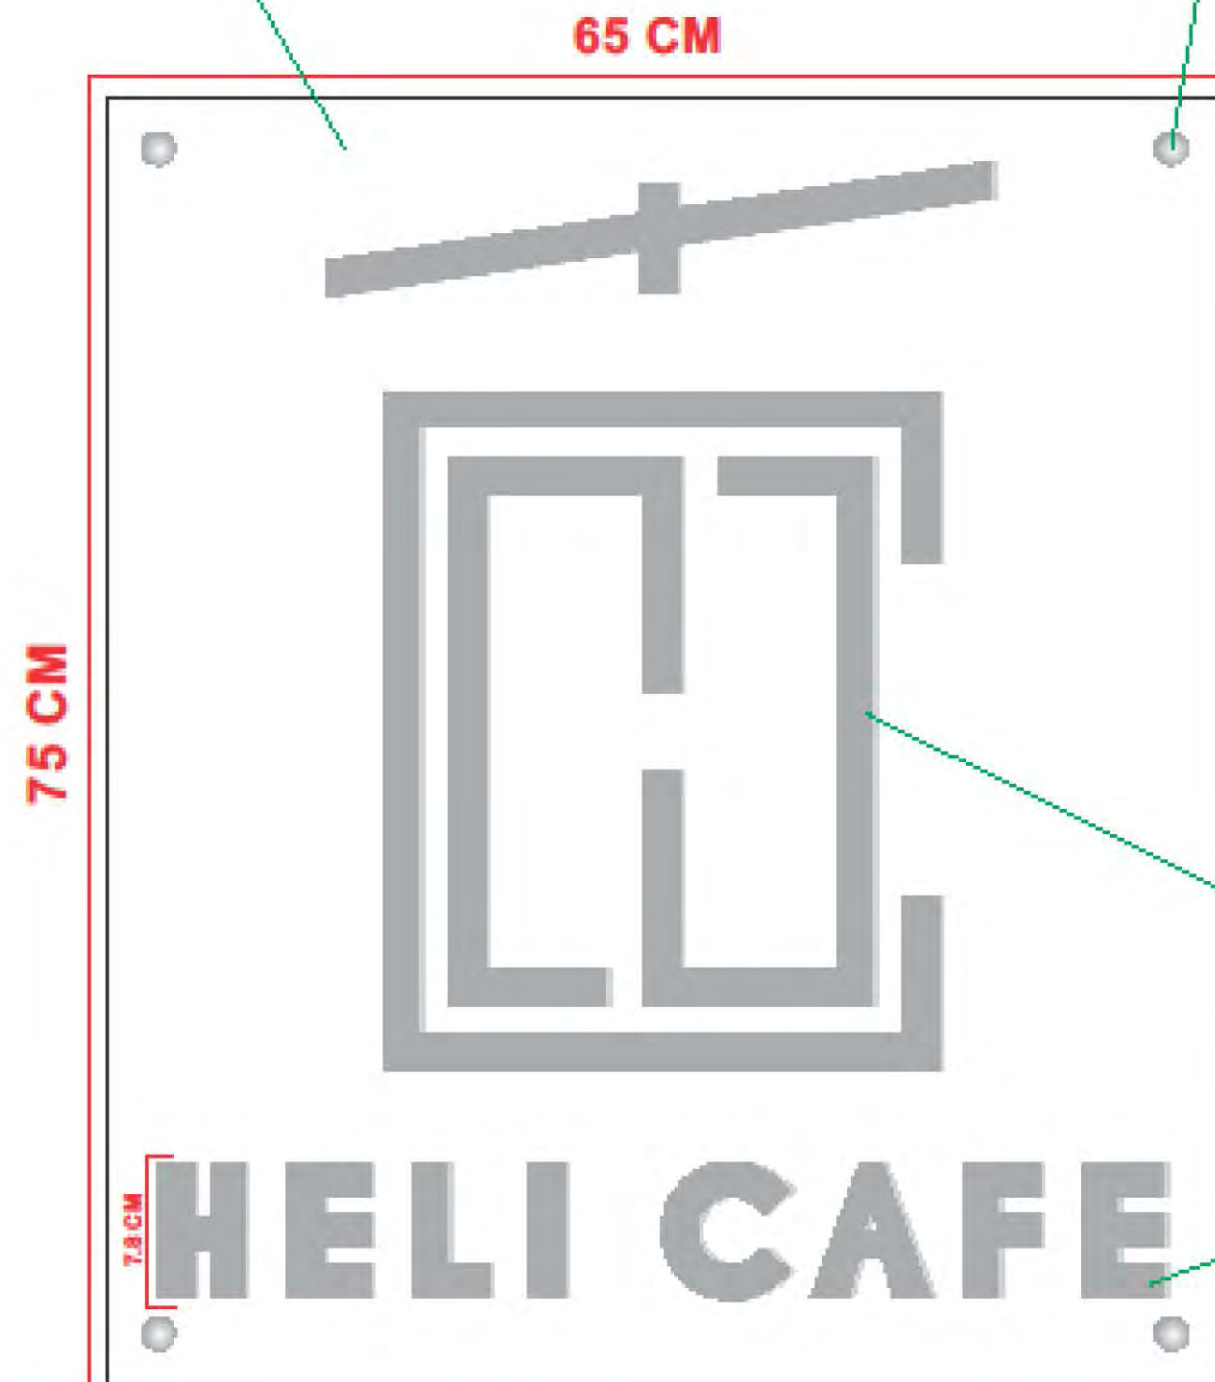

stainless steel 3D box letter with built-in LED Reverse Light